



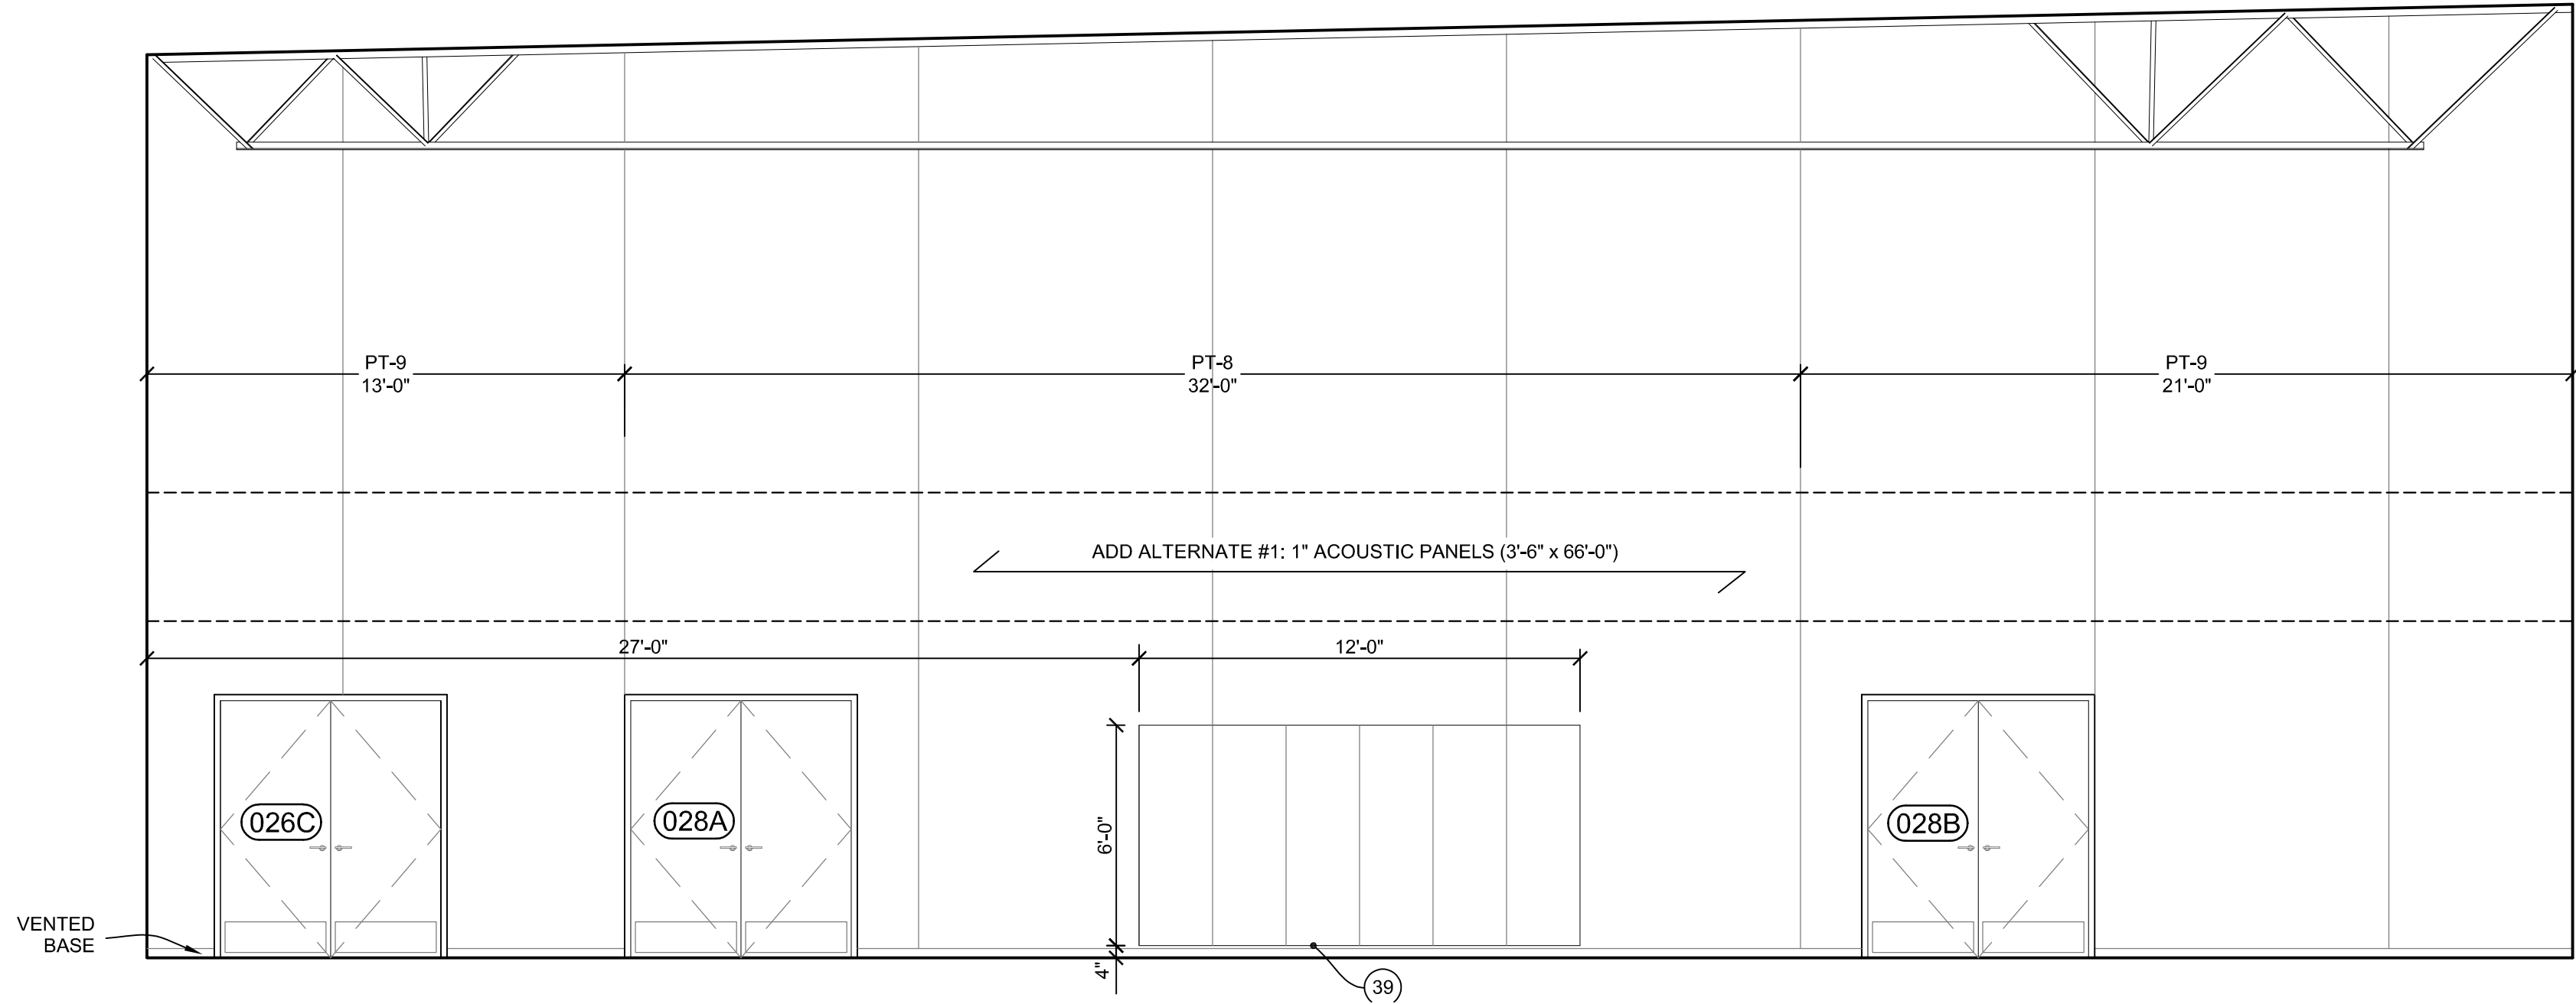

1 GYMNASIUM RM 026
A704 1/4" = 1'-0"

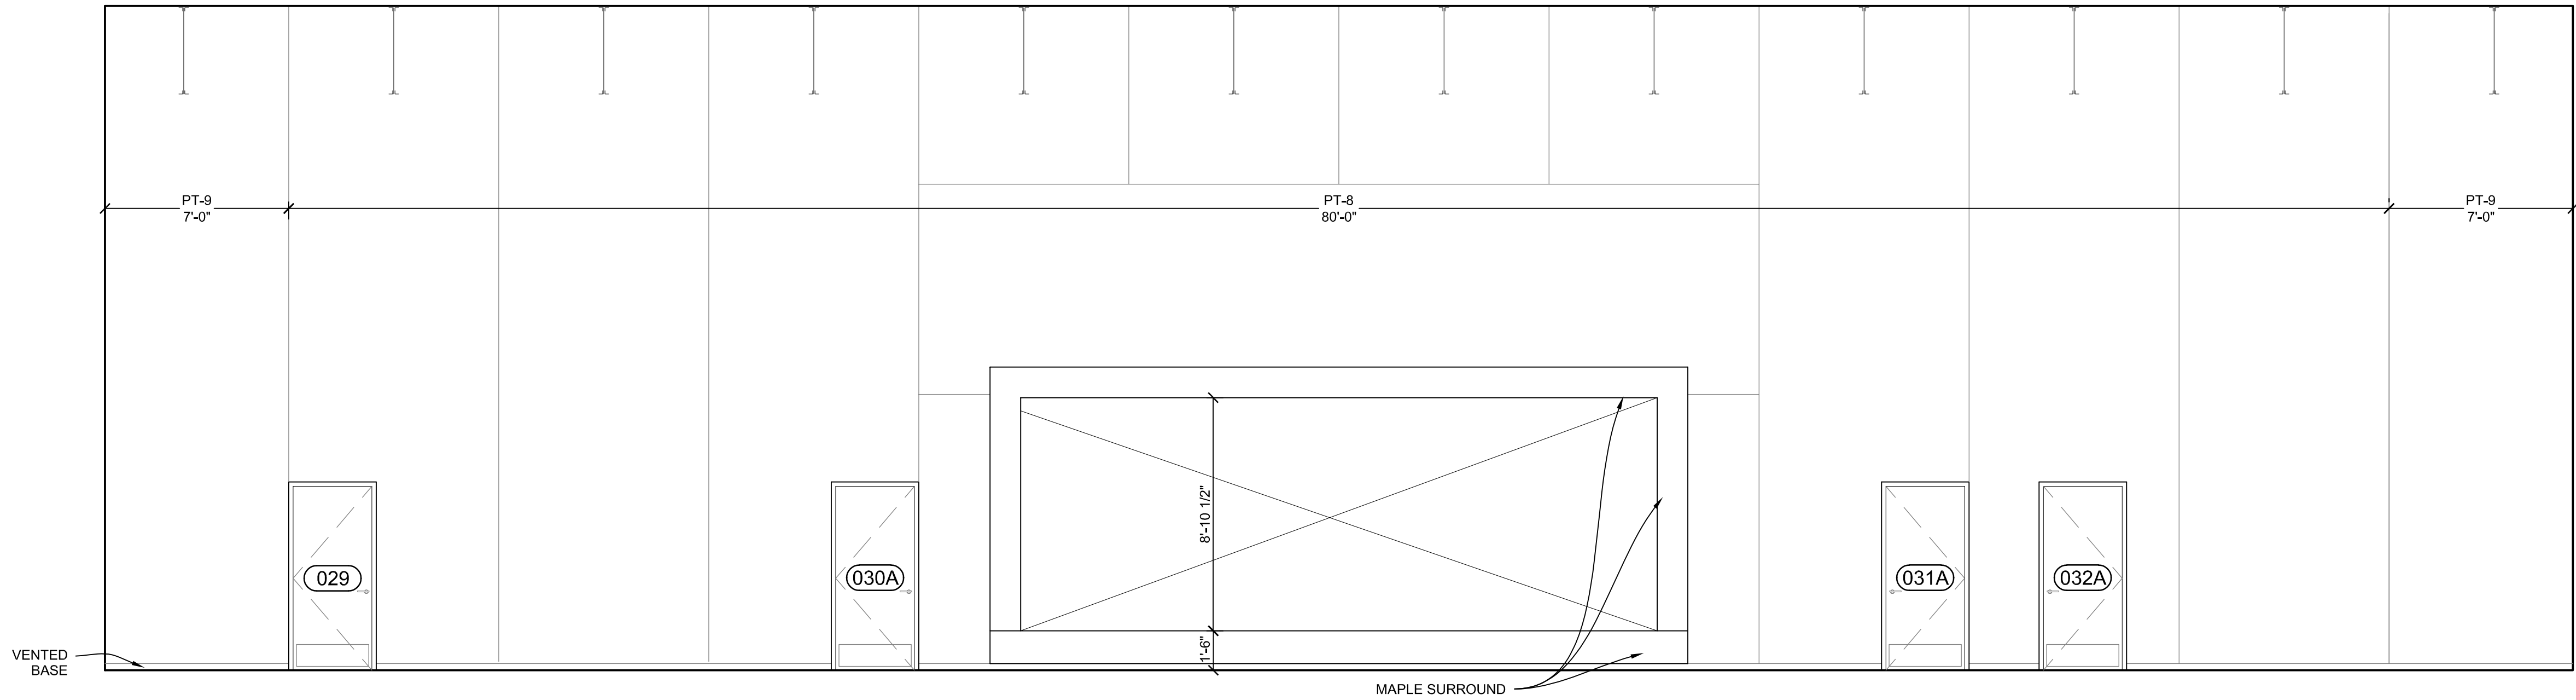

2 GYMNASIUM RM 026
A704 1/4" = 1'-0"



GENERAL NOTES

1. UNLESS A SPECIFIC MANUFACTURER/MODEL IS CALLED OUT, RESTROOM FIXTURES AND ACCESSORIES ARE TO BE SELECTED BY OWNER.
2. G.C. TO SUPPLY FIXTURES AND ACCESSORIES UNLESS DIRECTED OTHERWISE BY OWNER.

KEYNOTES - INT ELEVATIONS

1. FRAME LESS MIRROR 42" X 108"
2. WALL HUNG SINK, SEE TYP. MOUNTING HEIGHTS FOR CHILDREN; 39/A501
3. WALL HUNG SINK, SEE TYP. MOUNTING HEIGHTS (38/A700)
4. SURFACE MOUNTED HAND DRYER, SEE TYP. MOUNTING HEIGHTS FOR CHILDREN (39 / A700)
5. SURFACE MOUNTED HAND DRYER, SEE TYP. MOUNTING HEIGHTS (40/A700)
6. WALL HUNG CHILD SIZE TOILET, SEE TYP. MOUNTING HEIGHTS FOR CHILDREN (39/A700)
7. FLOOR MOUNTED FLUSH VALVE ADULT TOILET, SEE TYP. MOUNTING HEIGHTS (40/A700)
8. WALL HUNG TOILET, SEE TYP. MOUNTING HGTS (40/A700)
9. WALL HUNG URINAL, SEE TYP. MOUNTING HGTS (40/A700)
10. GRAB BARS, SEE TYP. MOUNTING HEIGHTS FOR CHILDREN (39/A700)
11. GRAB BARS, SEE TYP. MOUNTING HEIGHTS (40/A700)
12. SANITARY NAPKIN DISPENSER, SEE TYP. MOUNTING HEIGHTS (40/A700)
13. SURFACE MOUNTED TOILET PAPER DISPENSER, SEE TYP. MOUNTING HEIGHTS FOR CHILDREN (39/A700)
14. SURFACE MOUNTED TOILET PAPER DISPENSER, SEE TYP. MOUNTING HEIGHTS (40/A700)
15. SURFACE MOUNTED SOAP DISPENSER, SEE TYP. MOUNTING HEIGHTS FOR KIDS (39/A700)
16. SURFACE MOUNTED SOAP DISPENSER, SEE TYP. MOUNTING HEIGHTS (40/A700)
17. SOLID SURFACE COUNTER WITH INTEGRAL SINK BOWL
18. INTEGRAL SOAP DISPENSER
19. BABY CHANGING STATION SEE TYP. MOUNTING HEIGHTS (40/A700)
20. HINY HIDER TOILET PARTITIONS, SS 4 SEE FINISH LIST
21. STAINLESS STEEL UNDERMOUNT SINK
22. CLOSET ROD FOR COAT
23. ADJUSTABLE SHELF, TYP.
24. WIRE PULLS, TYP.
25. WIRE HOOKS, TYP.
26. 24" X 36" MIRROR
27. 18" X 30" MIRROR
28. SLIDING CLOSET DOORS, SEE DOOR SCHEDULE
29. BRACKETS FOR SOLID SURFACE BENCH, SEE DETAIL
30. WATER FOUNTAIN SEE TYP. MOUNTING HEIGHTS (40/A700)
31. DEVISING WALL, SEE DETAIL.
32. ART RAIL, SEE DETAIL
33. WHITE BOARD
34. TACK BOARD
35. ROLLER SHADES, SEE FINISH LIST
36. FULL LENGTH VERTICAL MIRROR, 24" X 60"
37. FRAME LESS MIRROR 42" X 60"
38. WALKER DISPLAY ART RAIL SYSTEM
39. VINYL GYMNASIUM WALL PAD, SEE FINISH LIST

HOLY FAMILY ACADEMY
PARISH LIFE CENTER ADDITION

5925 WEST LAKE STREET
ST. LOUIS PARK, MN 55416

INTERIOR ELEVATIONS

180626.00





PERMIT ISSUE DATE: 02/28/2020
REVISIONS: 03/02/2020
ADDENDUM #1 09/25/2020
PR #8

292Design

292DESIGNGROUP

3533 E. LAKE STREET MINNEAPOLIS, MINNESOTA 55406 612.767.3773

A704

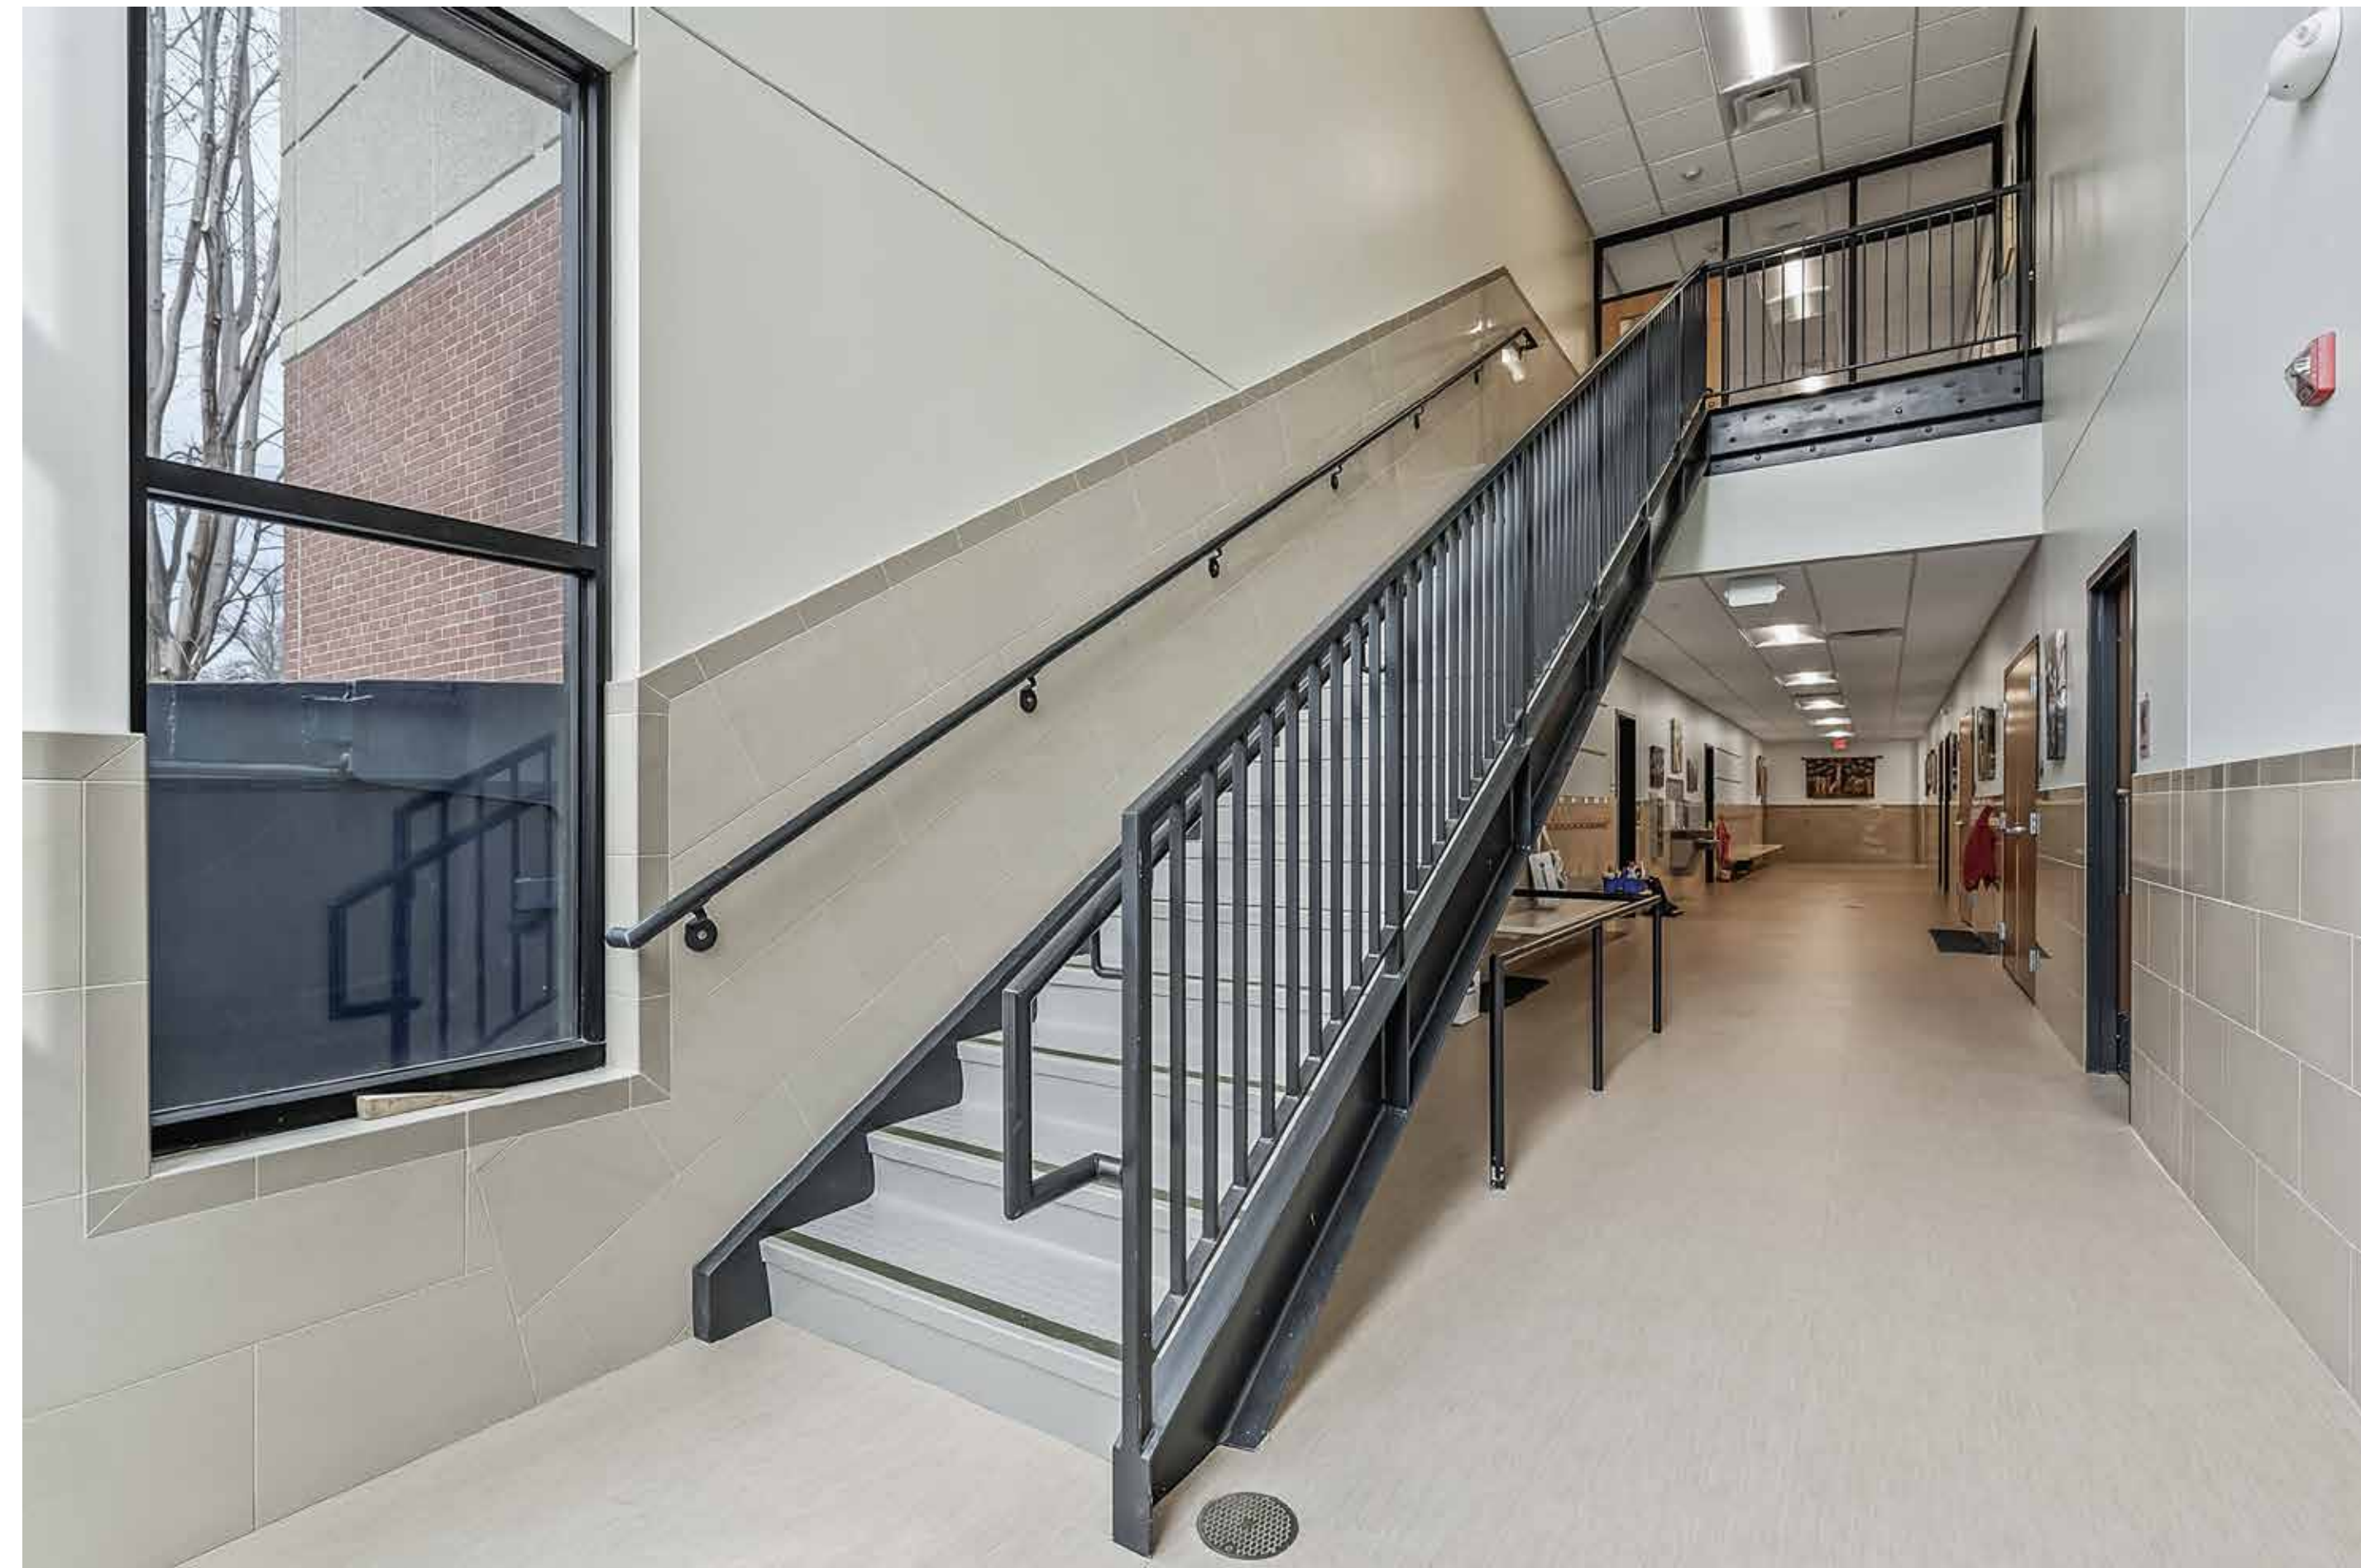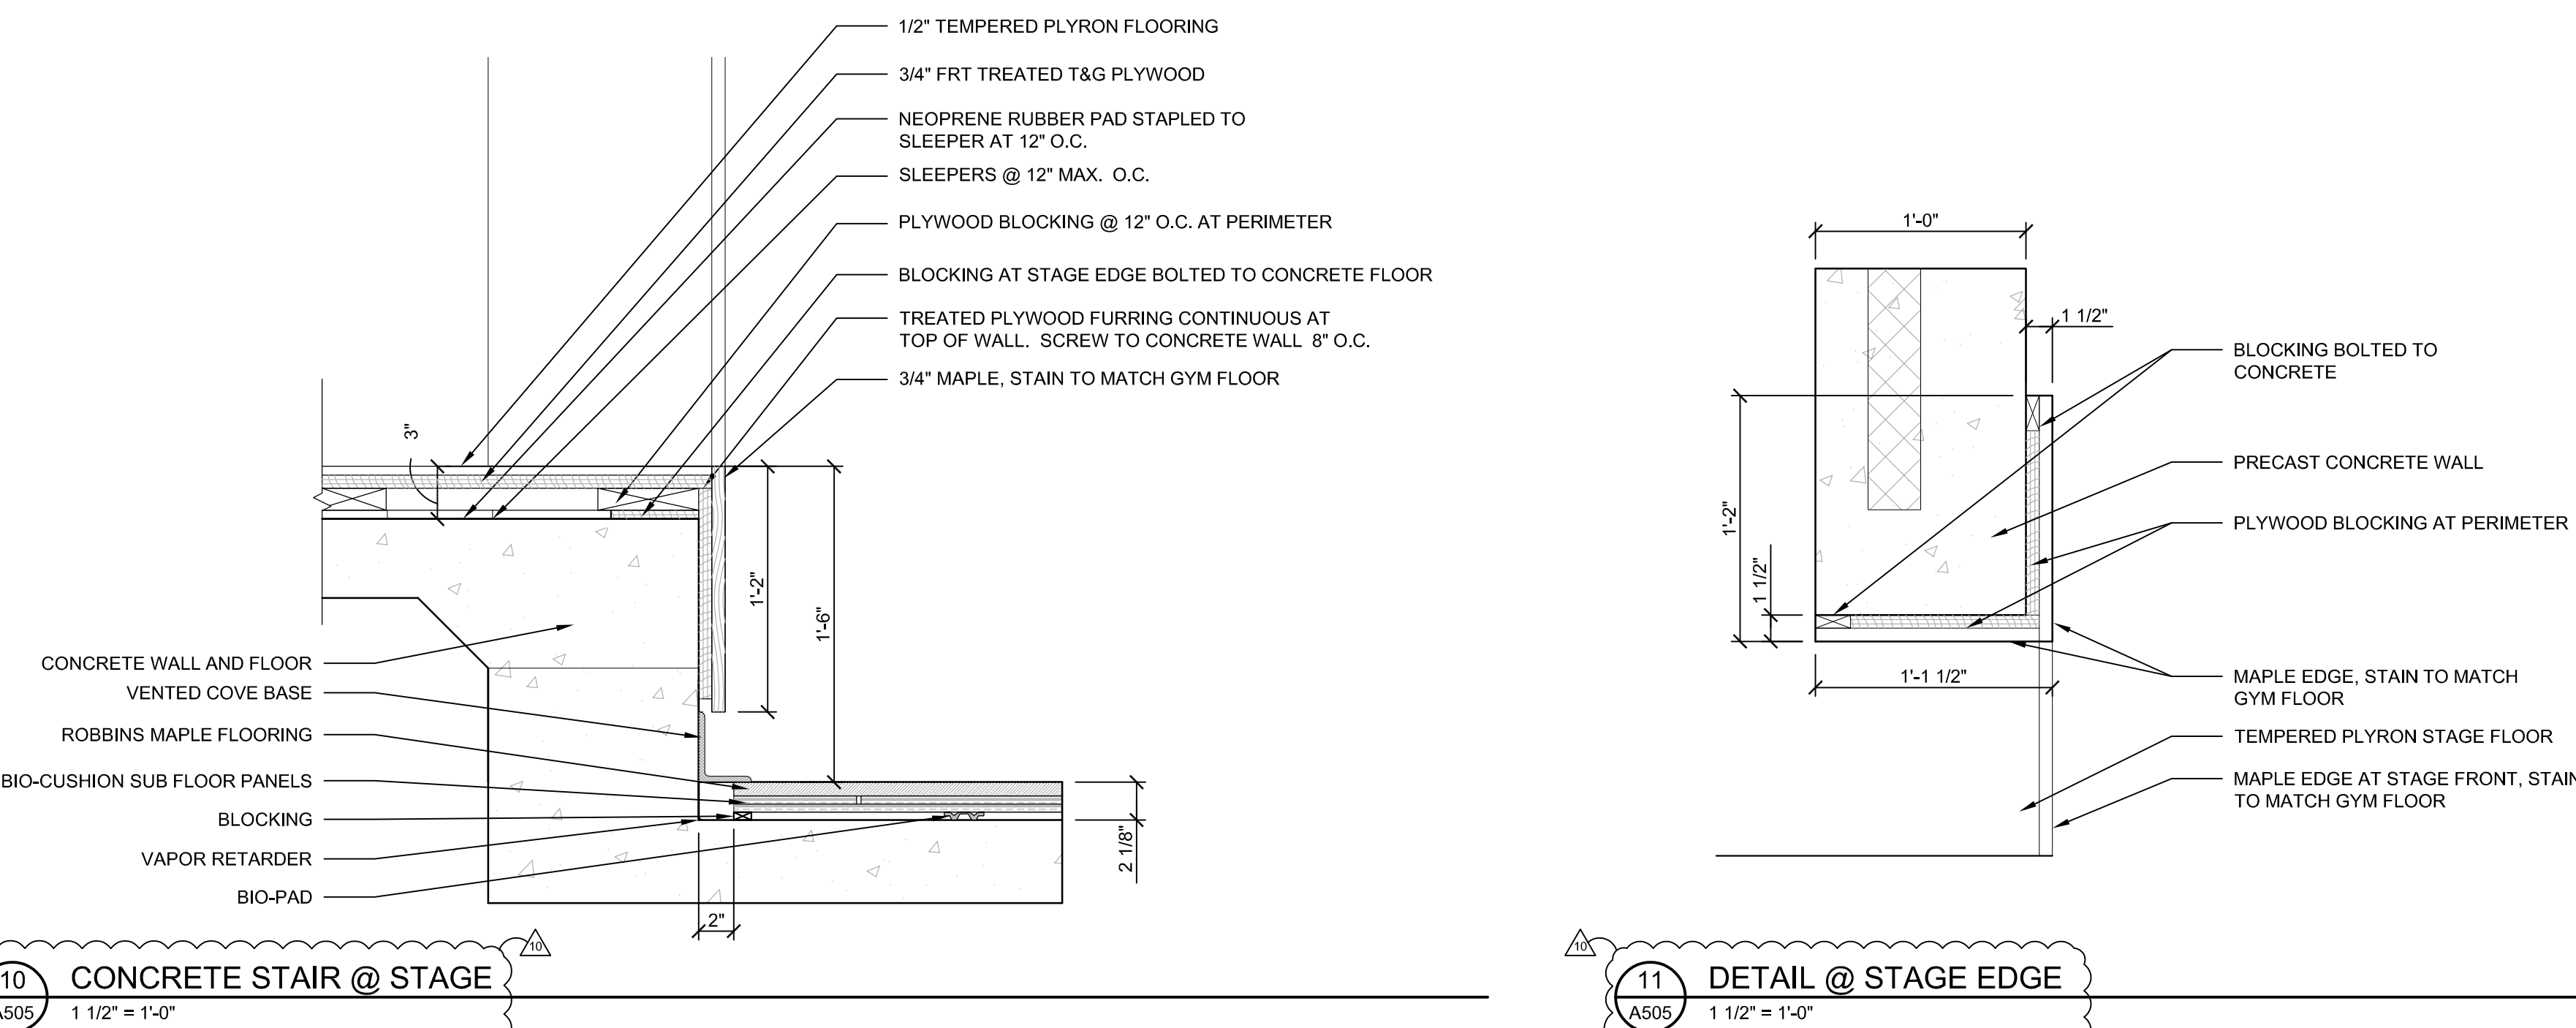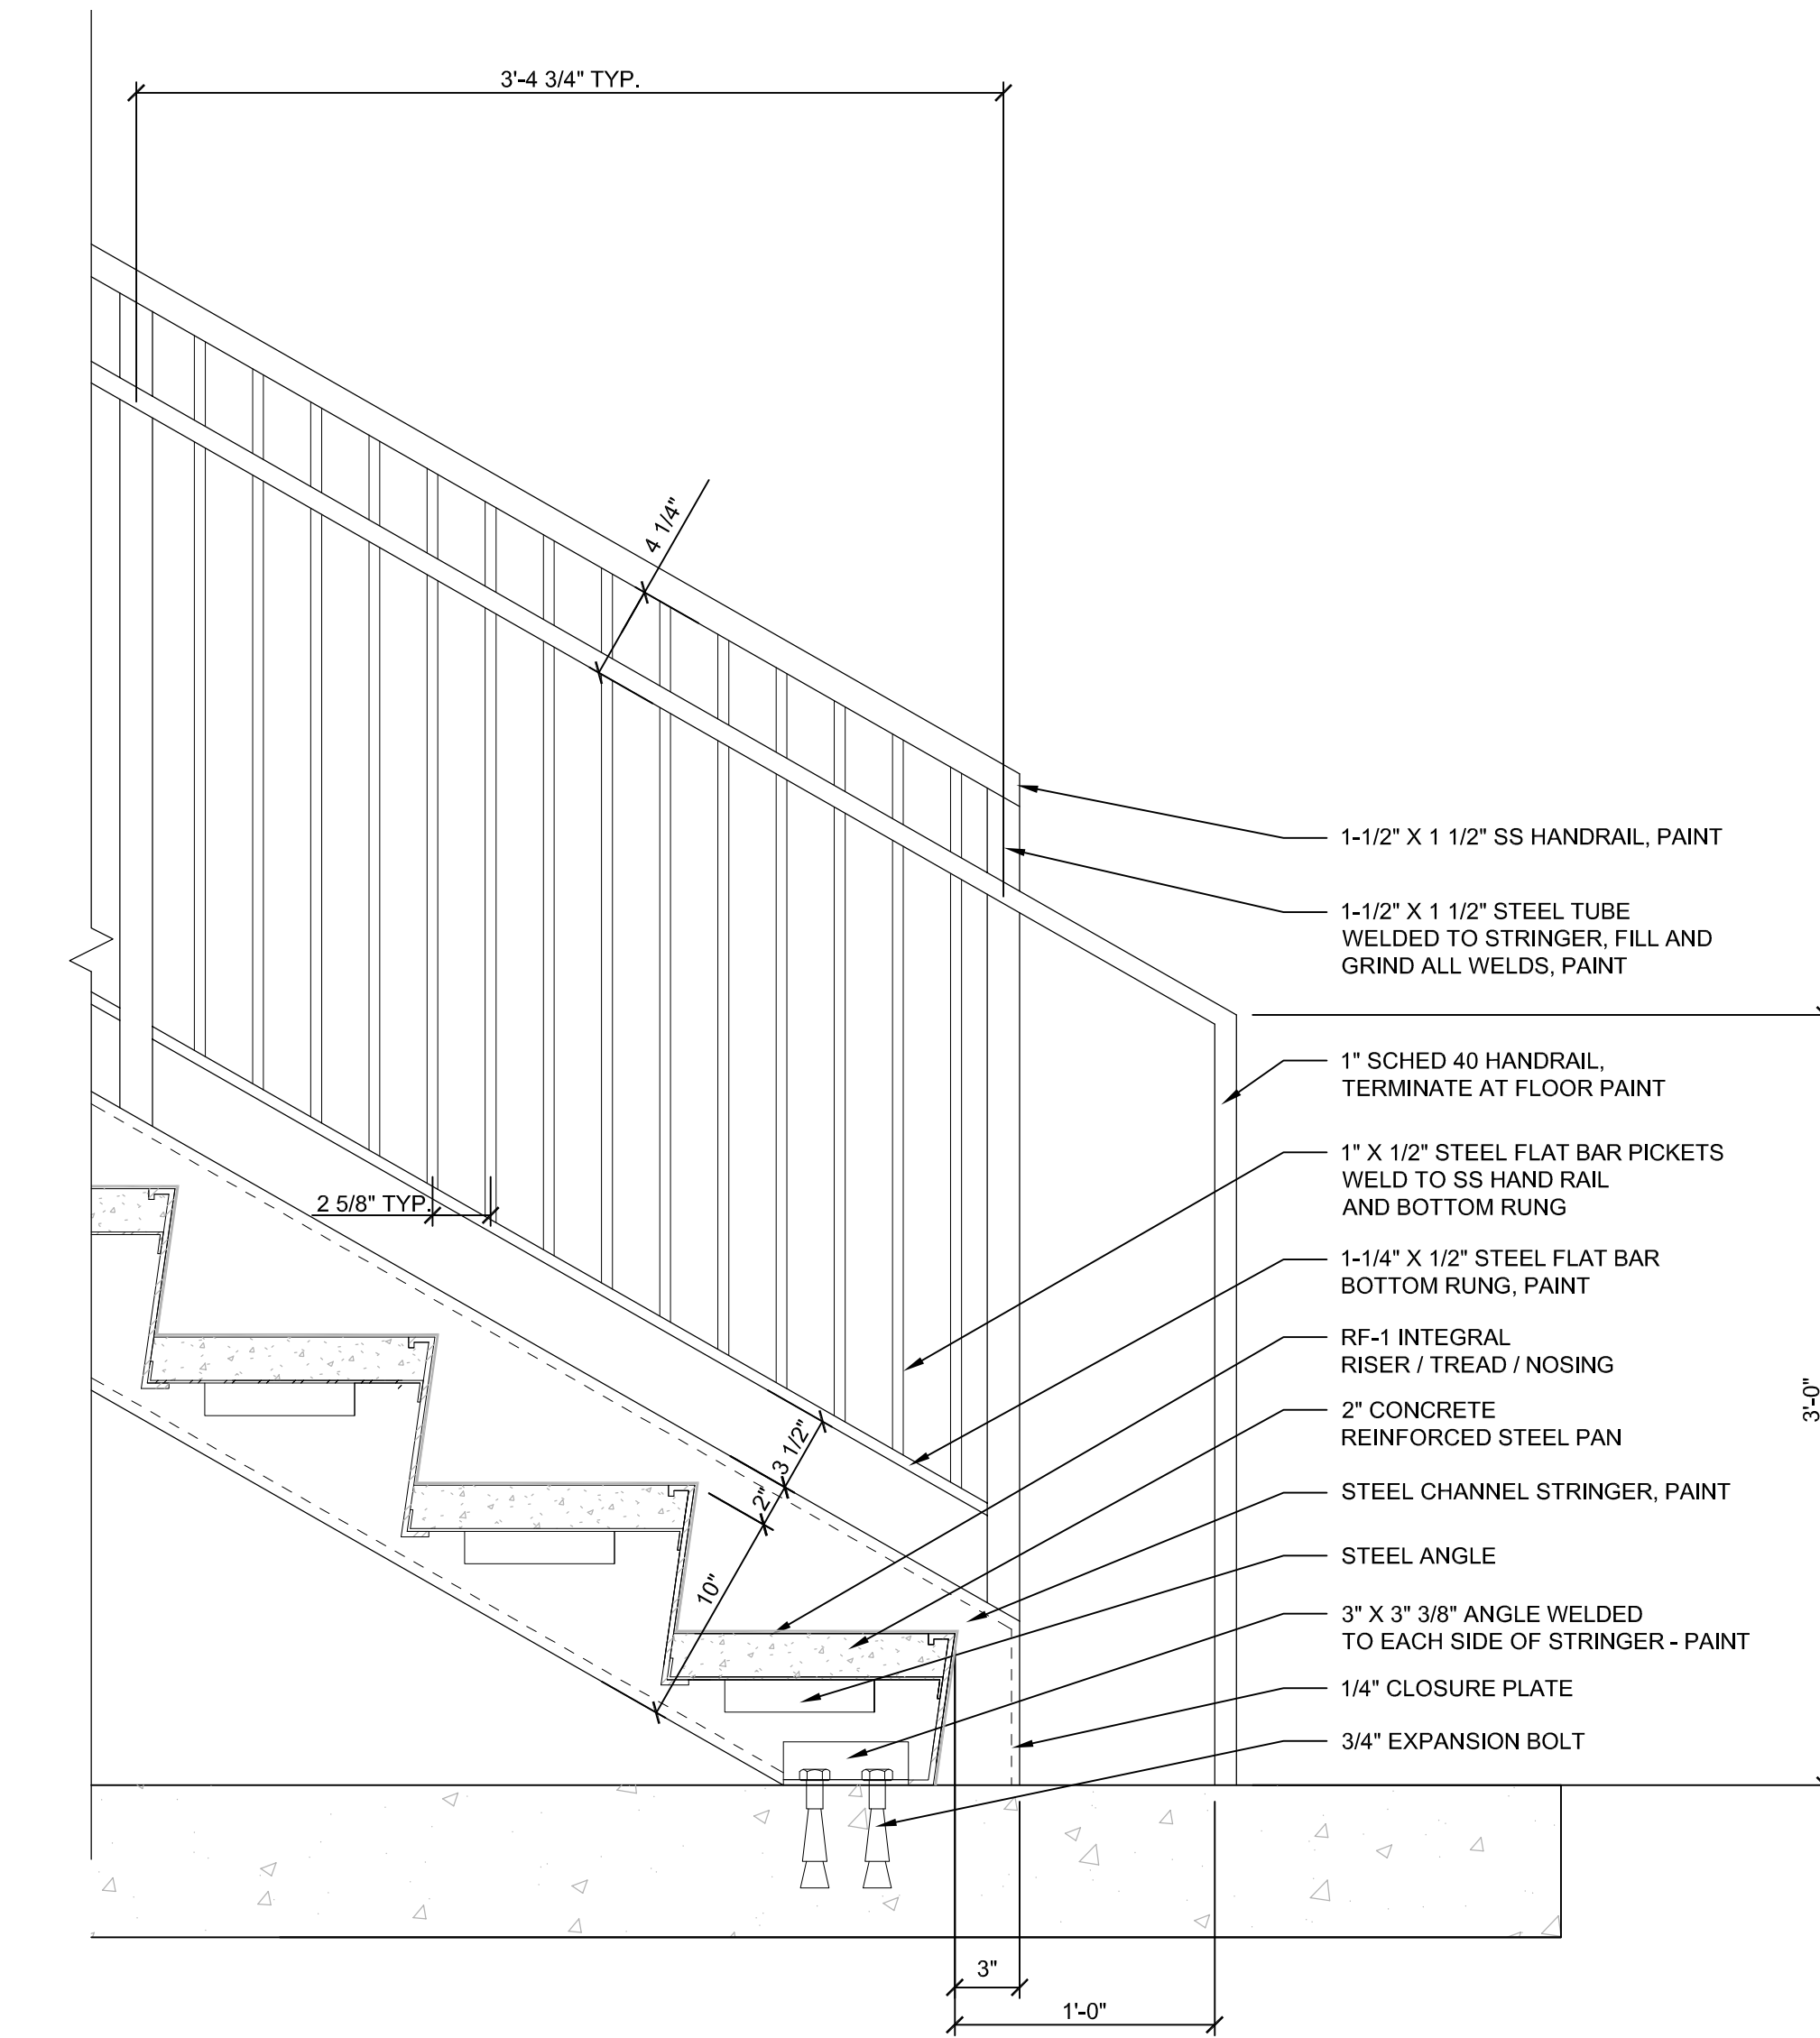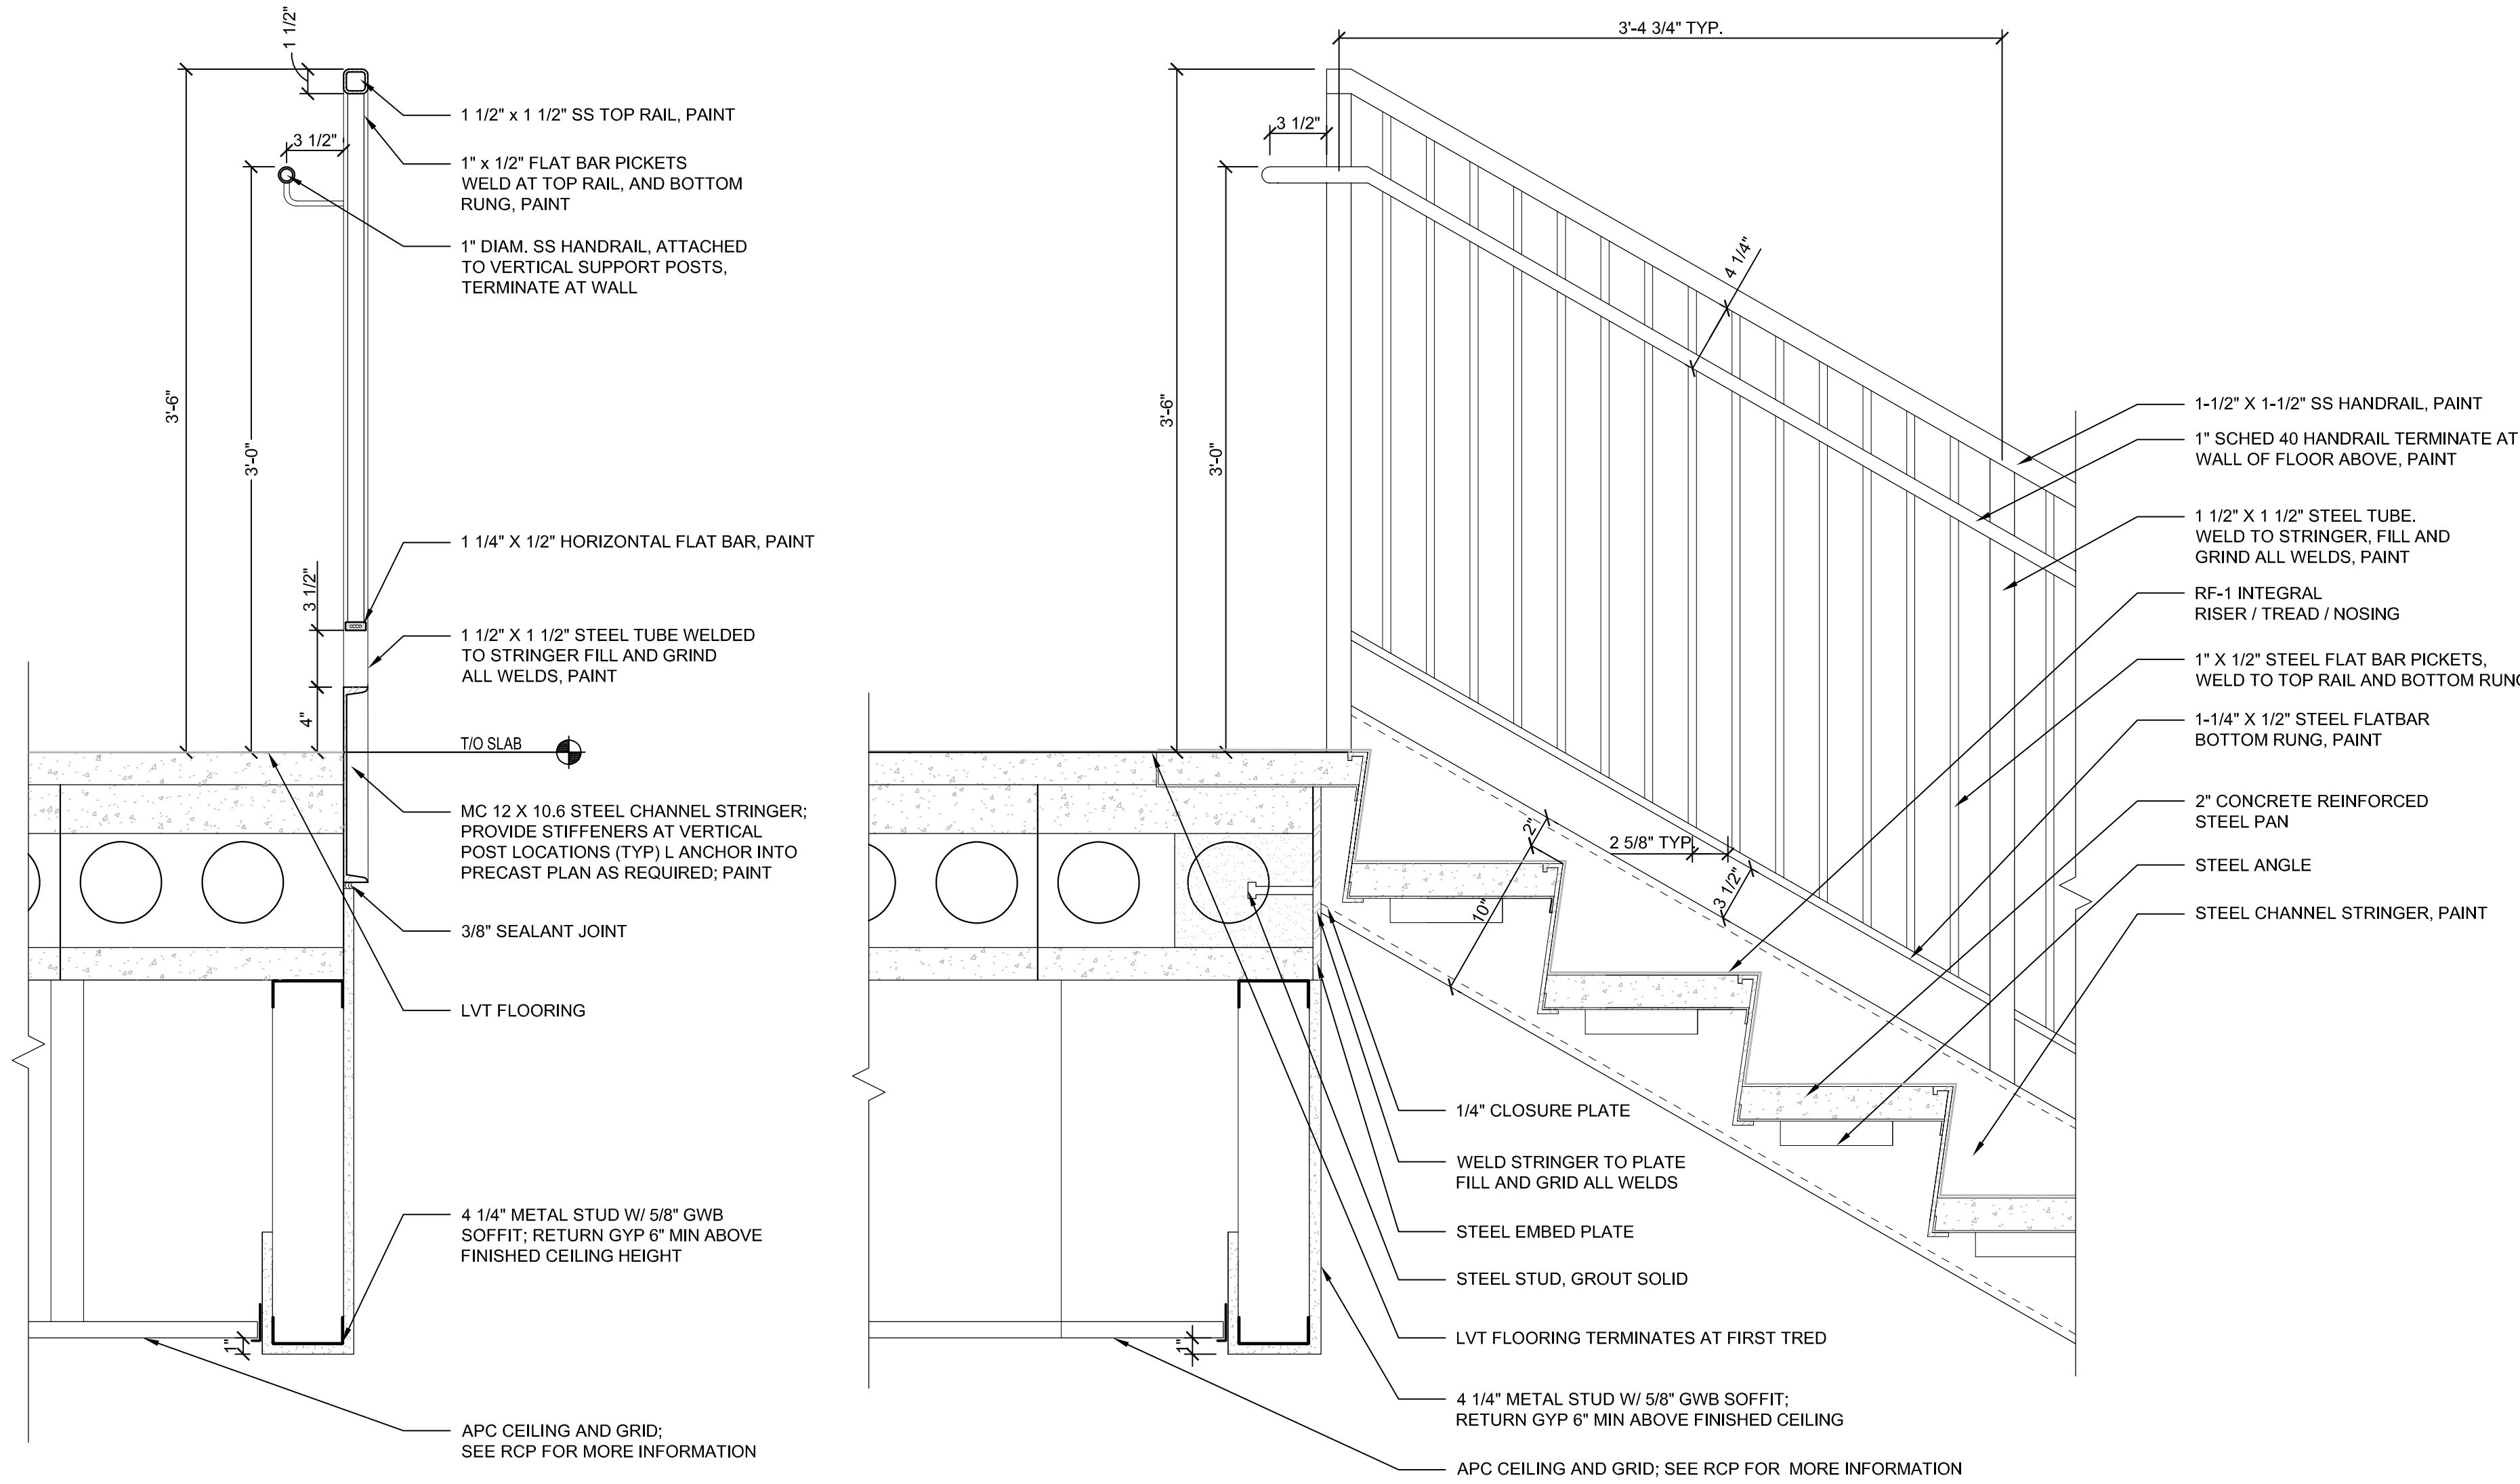

**HOLY FAMILY ACADEMY
PARISH LIFE CENTER ADDITION**
5925 WEST LAKE STREET
ST. LOUIS PARK, MN 55416
INTERIOR DETAILS
180651.00





A505

© 292 Design Group (2020)

PERMIT ISSUE DATE: 02.28.2020
REVISIONS: 07.30.2020
PR #4
09.08.2020
PR #6

292Desig

292DESIGNGROUP
3533 E. LAKE STREET MINNEAPOLIS, MINNESOTA 55406 612.767.3773

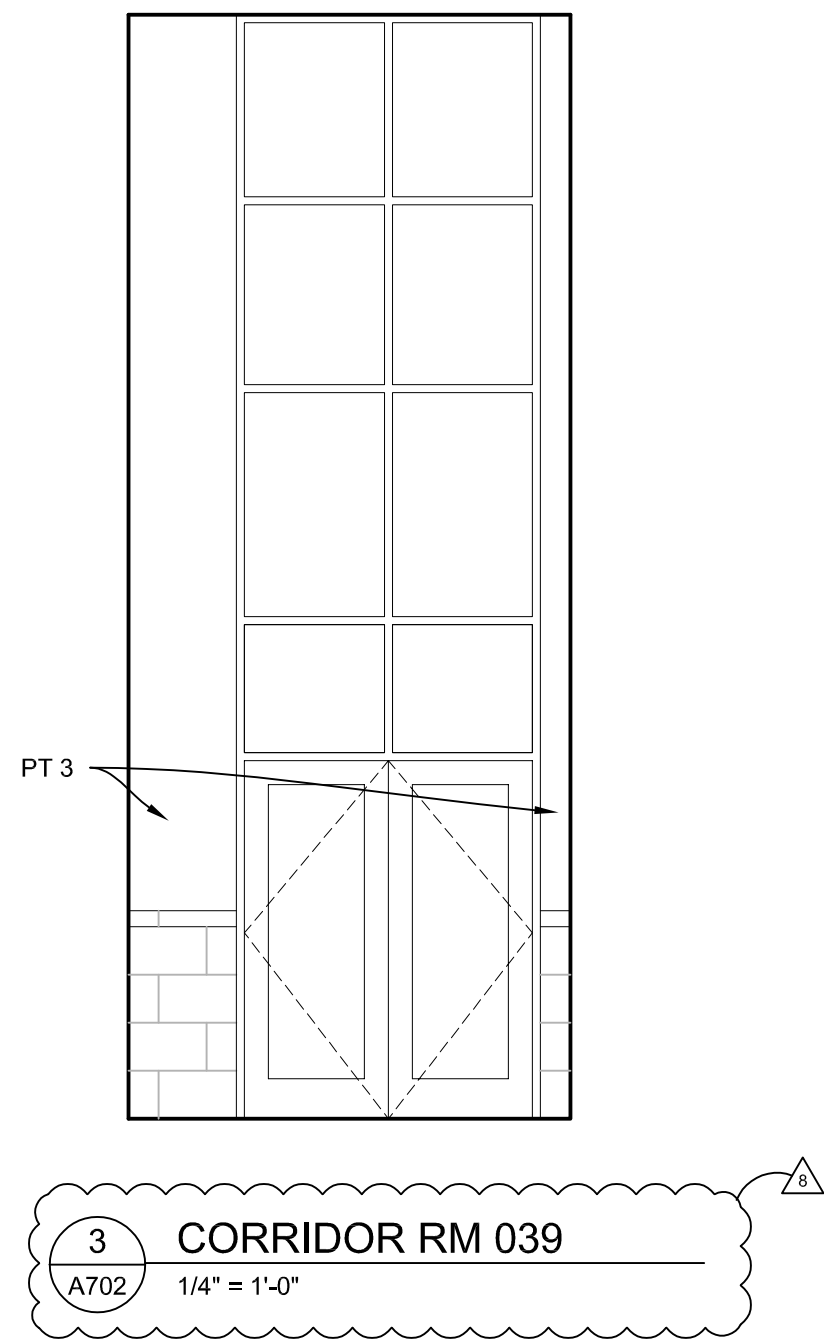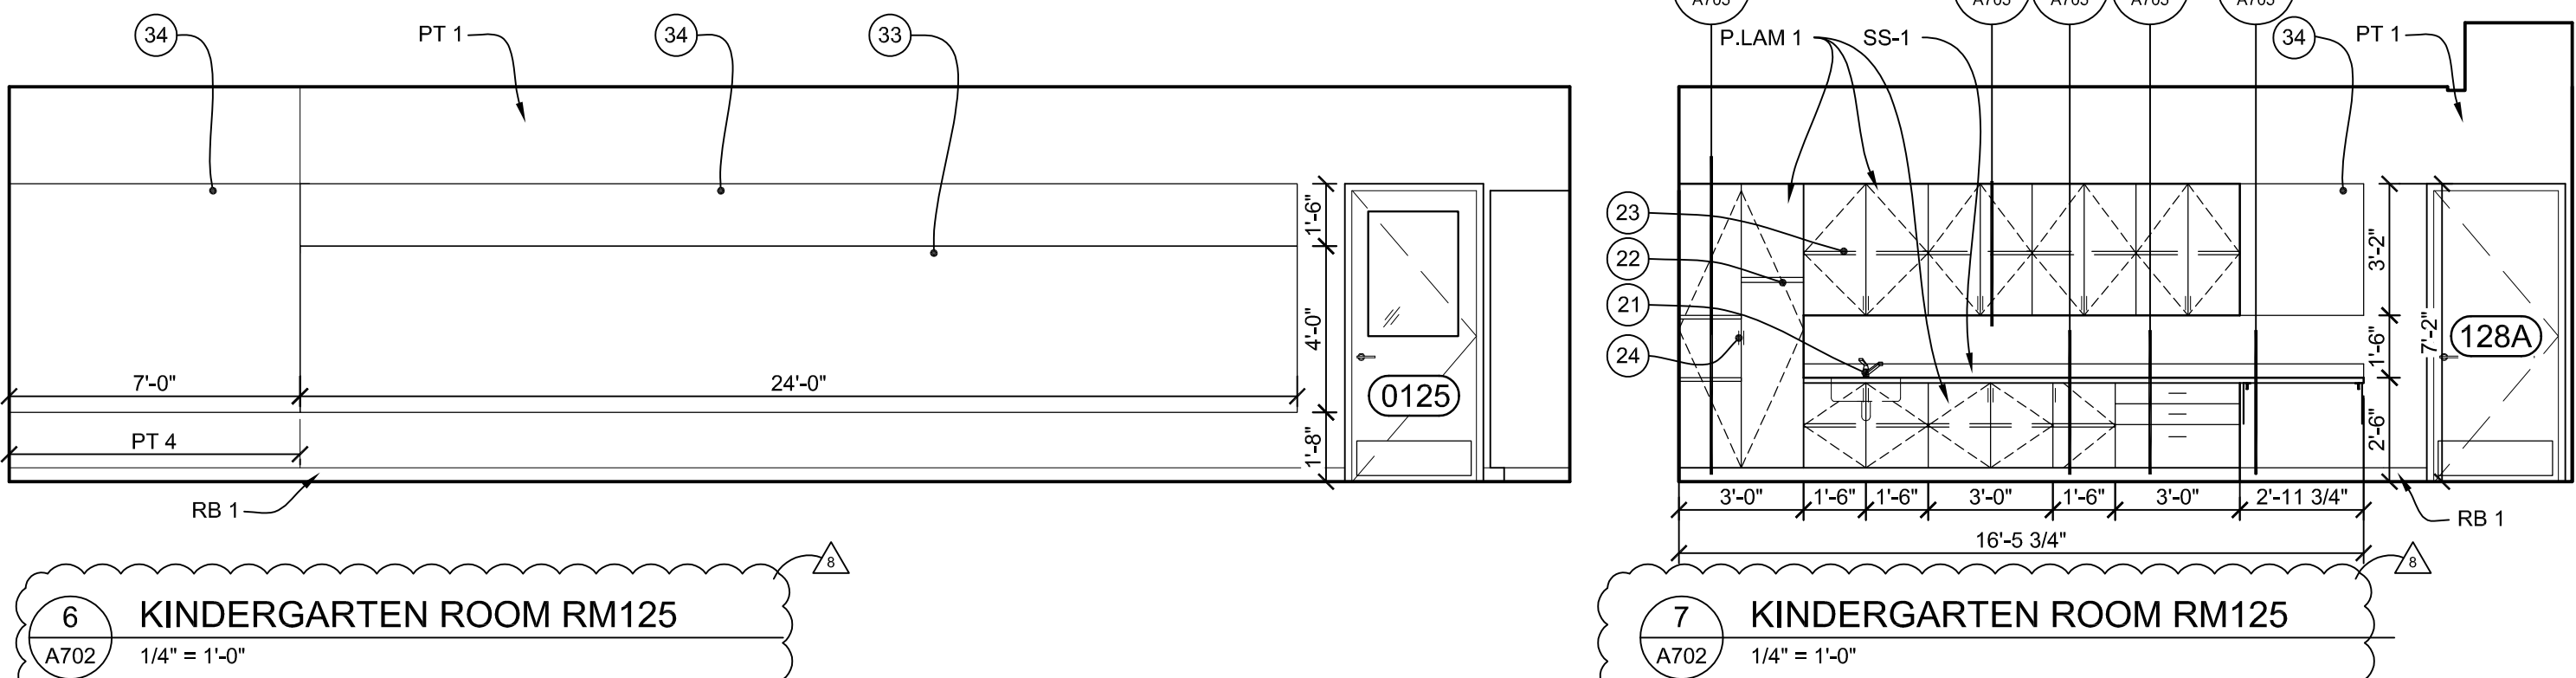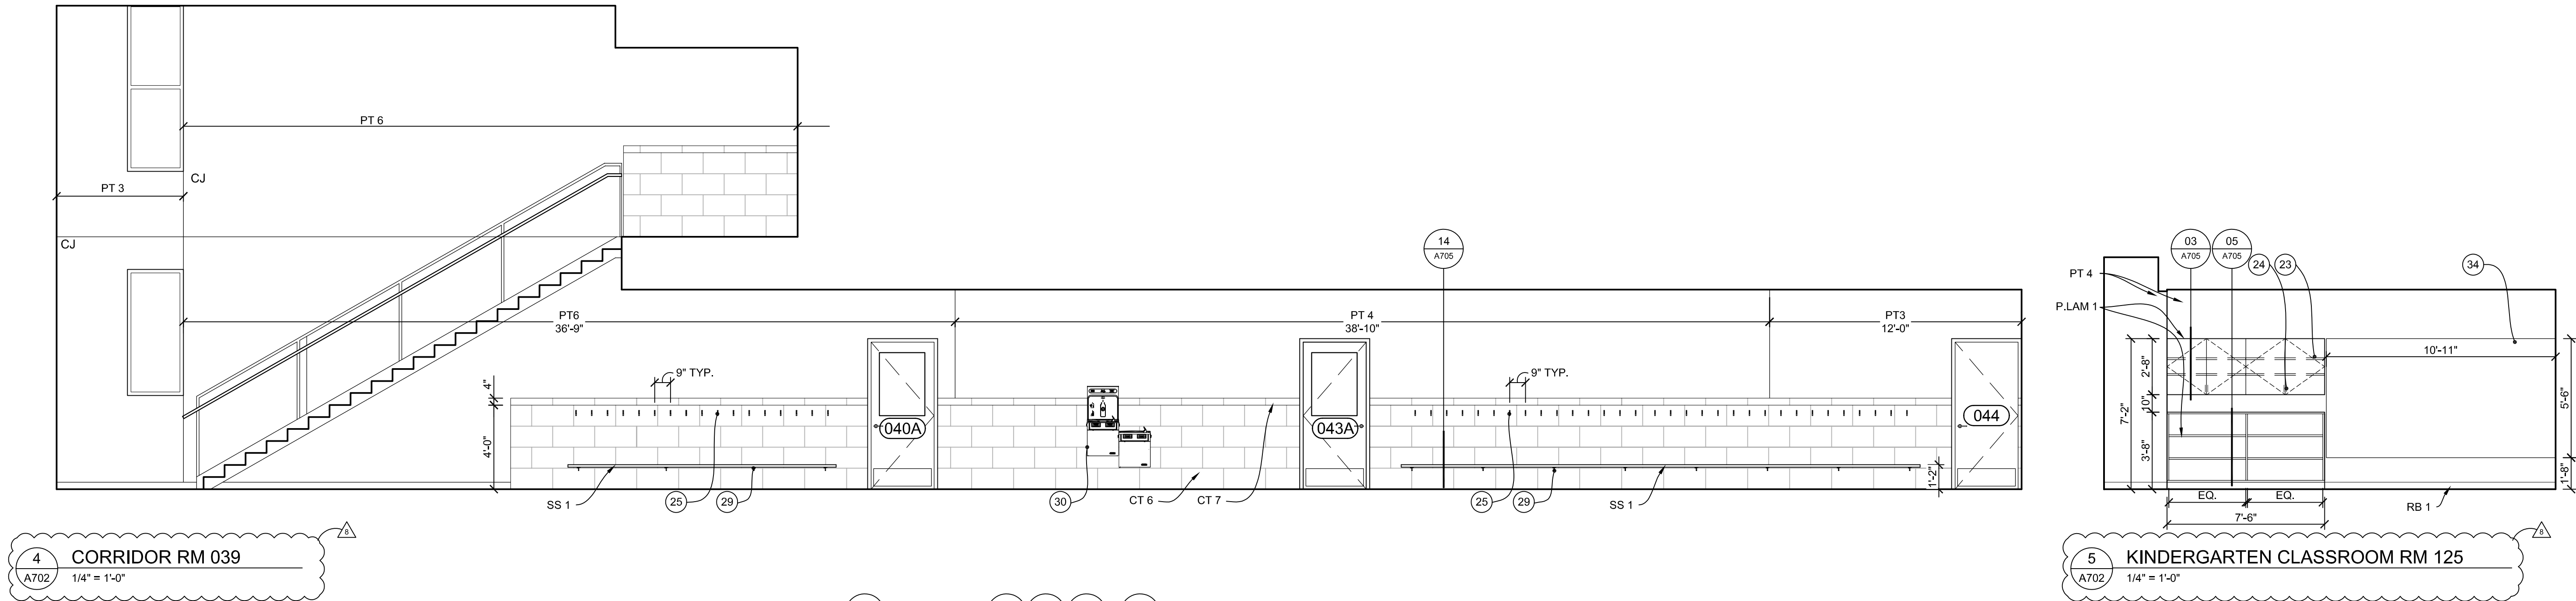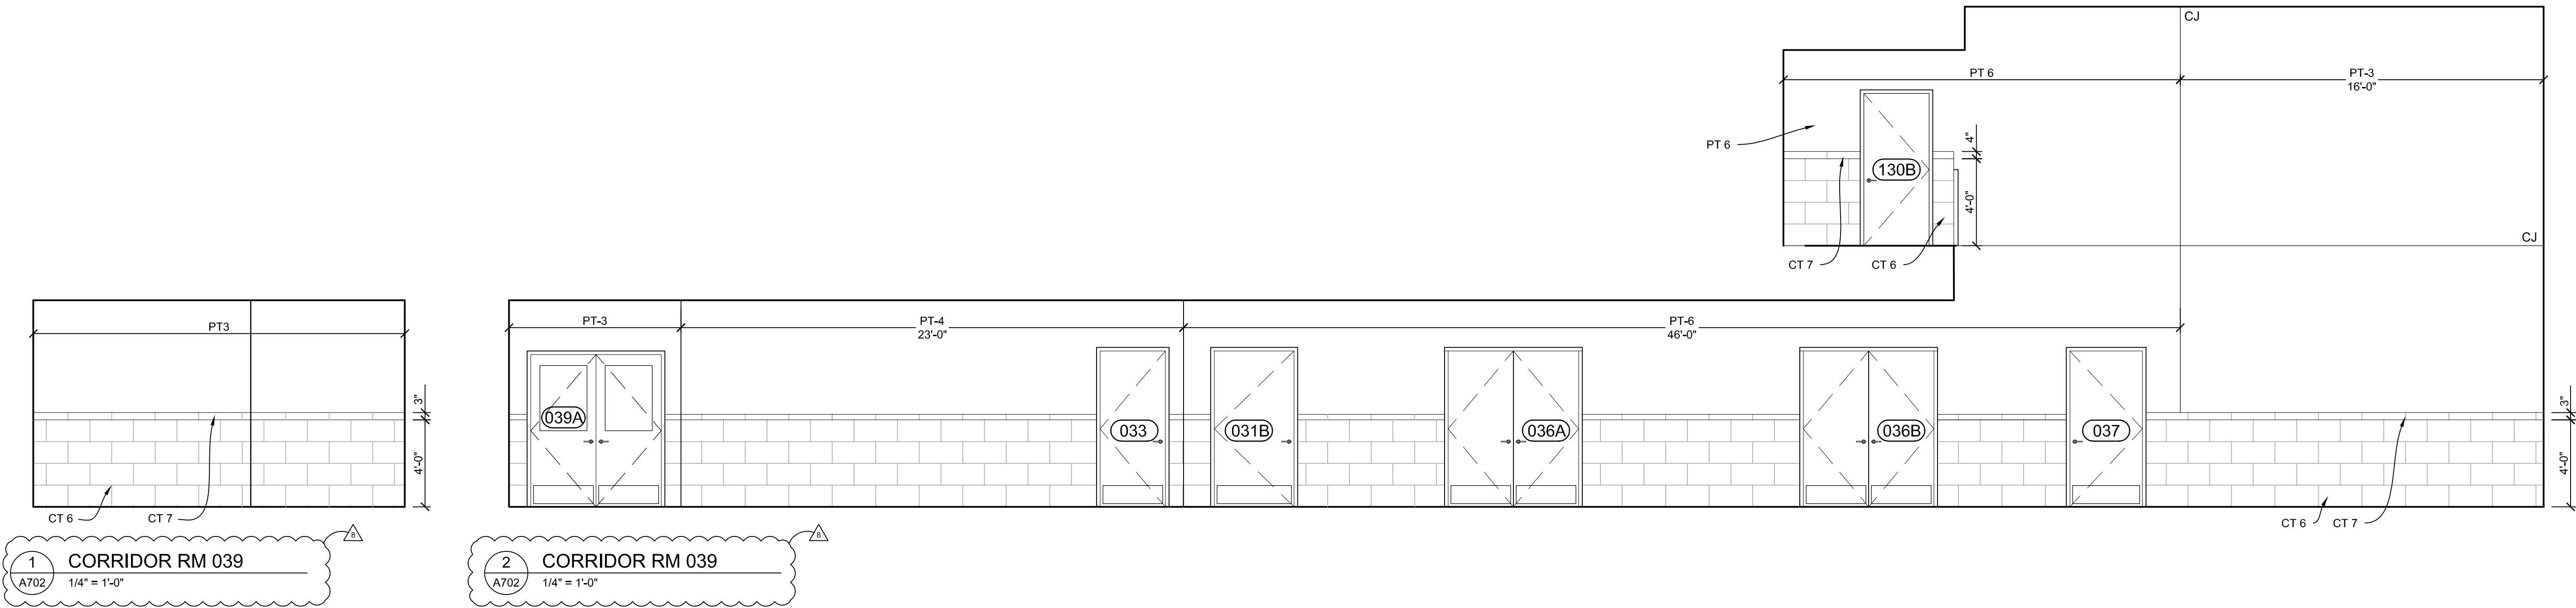

GENERAL NOTES

- UNLESS A SPECIFIC MANUFACTURER/MODEL IS CALLED OUT, RESTROOM FIXTURES AND ACCESSORIES ARE TO BE SELECTED BY OWNER.
- G.C. TO SUPPLY FIXTURES AND ACCESSORIES UNLESS DIRECTED OTHERWISE BY OWNER.

KEYNOTES - INT ELEVATIONS

- FRAME LESS MIRROR 42" X 108"
- WALL HUNG SINK, SEE TYP. MOUNTING HEIGHTS FOR CHILDREN: 39/A501
- WALL HUNG SINK, SEE TYP. MOUNTING HEIGHTS (39/A700)
- SURFACE MOUNTED HAND DRYER, SEE TYP. MOUNTING HEIGHTS FOR CHILDREN (39 / A700)
- SURFACE MOUNTED HAND DRYER, SEE TYP. MOUNTING HEIGHTS (40/A700)
- WALL HUNG CHILD SIZE TOILET, SEE TYP. MOUNTING HEIGHTS FOR CHILDREN (39/A700)
- FLOOR MOUNTED FLUSH VALVE ADULT TOILET, SEE TYP. MOUNTING HEIGHTS (40/A700)
- WALL HUNG TOILET, SEE TYP. MOUNTING HGTS (40/A700)
- WALL HUNG URINAL, SEE TYP. MOUNTING HGTS (40/A700)
- GRAB BARS, SEE TYP. MOUNTING HEIGHTS FOR CHILDREN (39/A700)
- GRAB BARS, SEE TYP. MOUNTING HEIGHTS (40/A700)
- SANITARY NAPKIN DISPENSER, SEE TYP. MOUNTING HEIGHTS (40/A700)
- SURFACE MOUNTED TOILET PAPER DISPENSER, SEE TYP. MOUNTING HEIGHTS FOR CHILDREN (39/A700)
- SURFACE MOUNTED TOILET PAPER DISPENSER, SEE TYP. MOUNTING HEIGHTS (40/A700)
- SURFACE MOUNTED SOAP DISPENSER, SEE TYP. MOUNTING HEIGHTS FOR KIDS (39/A700)
- SURFACE MOUNTED SOAP DISPENSER, SEE TYP. MOUNTING HEIGHTS (40/A700)
- SOLID SURFACE COUNTER WITH INTEGRAL SINK BOWL
- INTEGRAL SOAP DISPENSER
- BABY CHANGING STATION SEE TYP. MOUNTING HEIGHTS (40/A700)
- HINY HIDER TOILET PARTITIONS, SS 4 SEE FINISH LIST
- STAINLESS STEEL UNDERMOUNT SINK
- CLOSET ROD FOR COAT
- ADJUSTABLE SHELF, TYP.
- WIRE PULLS, TYP.
- WIRE HOOKS, TYP.
- 24" X 36" MIRROR
- 18" X 30" MIRROR
- SLIDING CLOSET DOORS, SEE DOOR SCHEDULE
- BRACKETS FOR SOLID SURFACE BENCH, SEE DETAIL
- WATER FOUNTAIN SEE TYP. MOUNTING HEIGHTS (40/A700)
- DEISING WALL, SEE DETAIL.
- ART RAIL, SEE DETAIL
- WHITE BOARD
- TACK BOARD
- ROLLER SHADES, SEE FINISH LIST
- FULL LENGTH VERTICAL MIRROR, 24" X 60"
- FRAME LESS MIRROR 42" X 60"
- WALKER DISPLAY ART RAIL SYSTEM
- VINYL GYMNASIUM WALL PAD, SEE FINISH LIST

HOLY FAMILY ACADEMY
PARISH LIFE CENTER ADDITION

5925 WEST LAKE STREET
ST. LOUIS PARK, MN 55416

INTERIOR ELEVATIONS


190550.00

A702


© 2022 Design Group (2022)

PERMIT ISSUE DATE: 02/28/2020
REVISIONS: 03/30/2020
ADDENDUM #1
PR #6


292Design
292DESIGNGROUP
3533 E. LAKE STREET MINNEAPOLIS, MINNESOTA 55406 612.767.3773

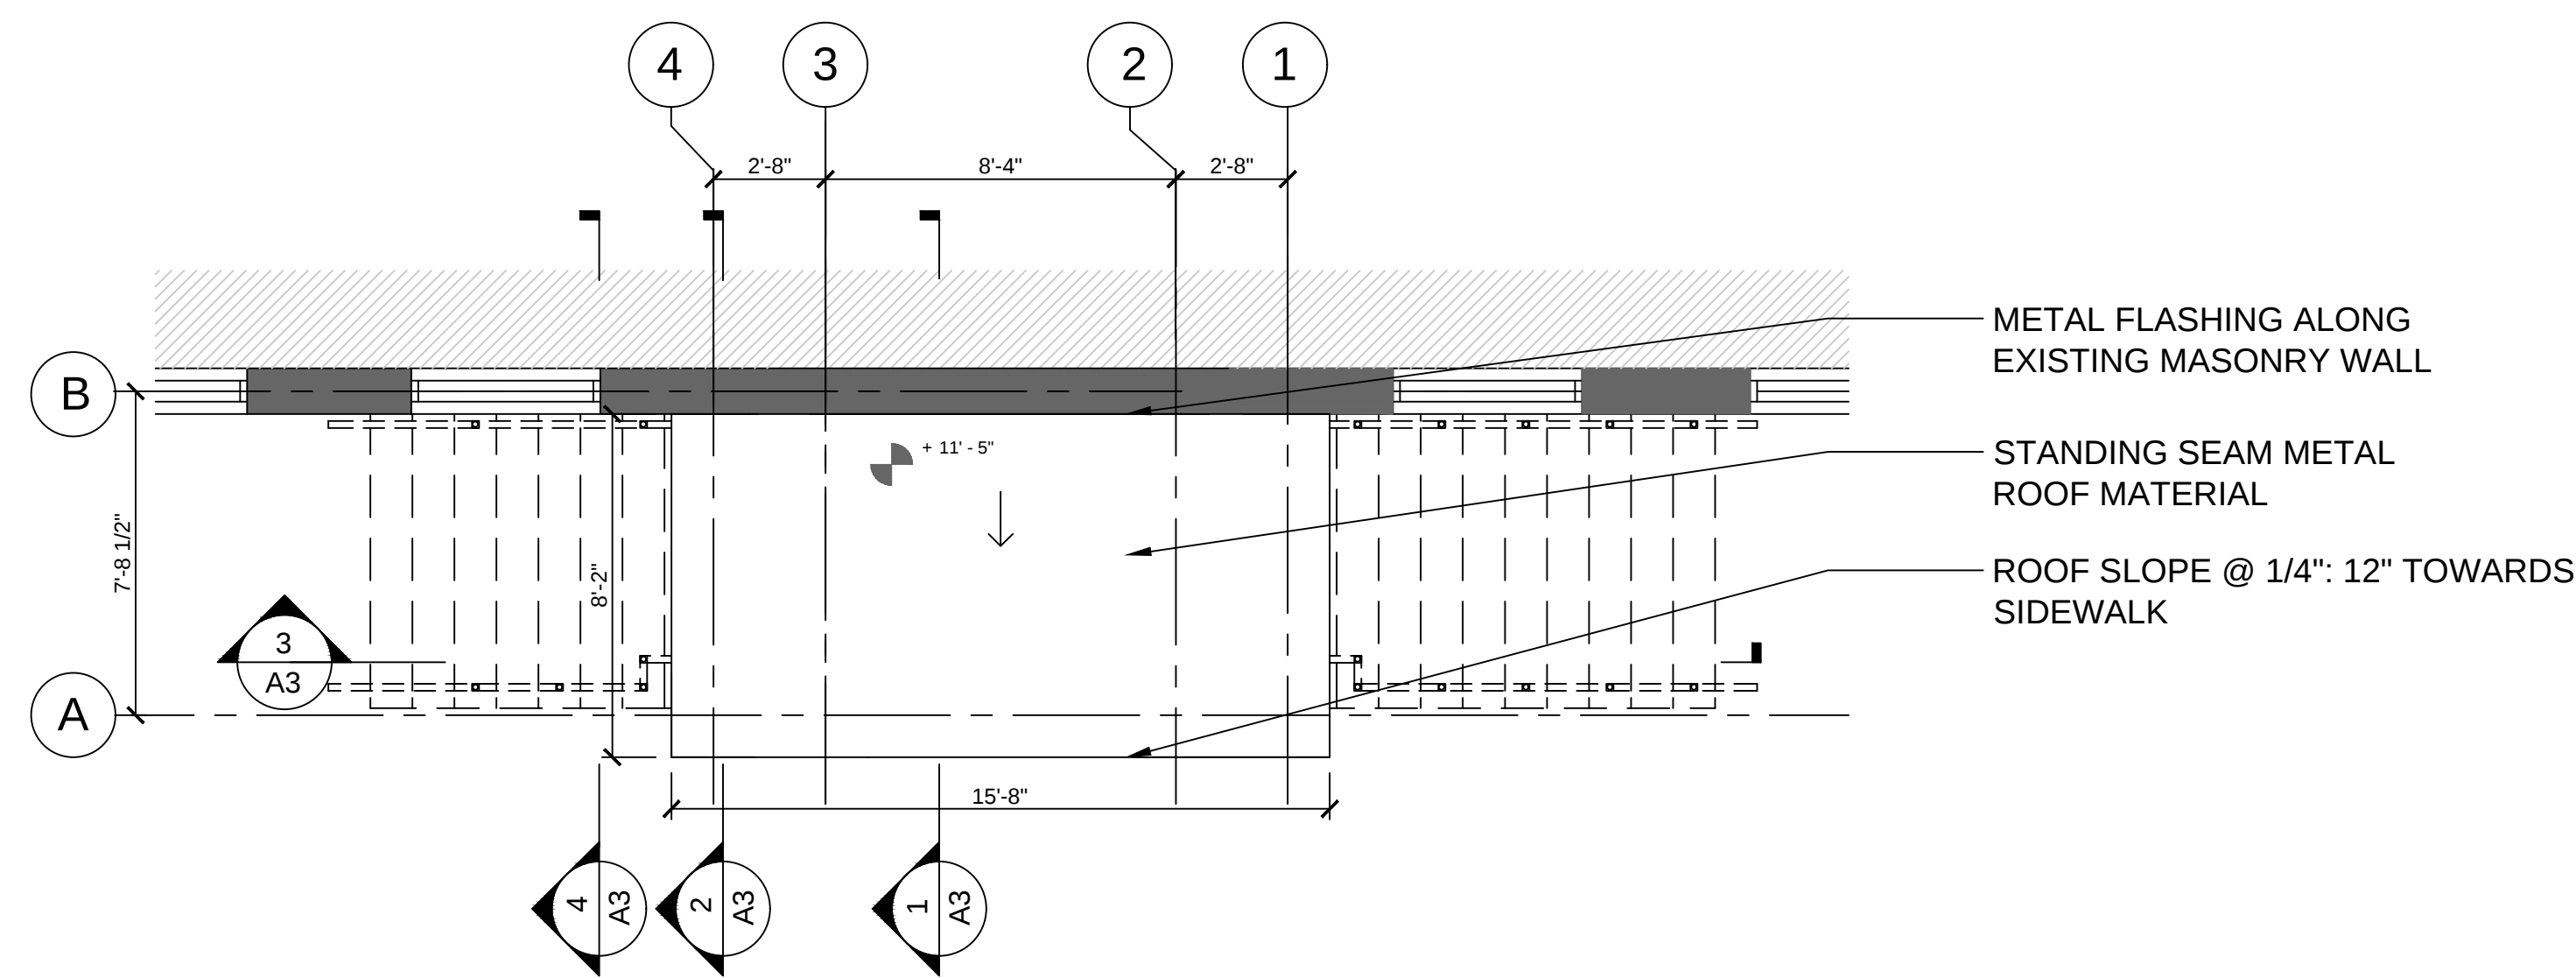

4 PORTICO ROOF PLAN
Scale: 1/4" = 1'-0"

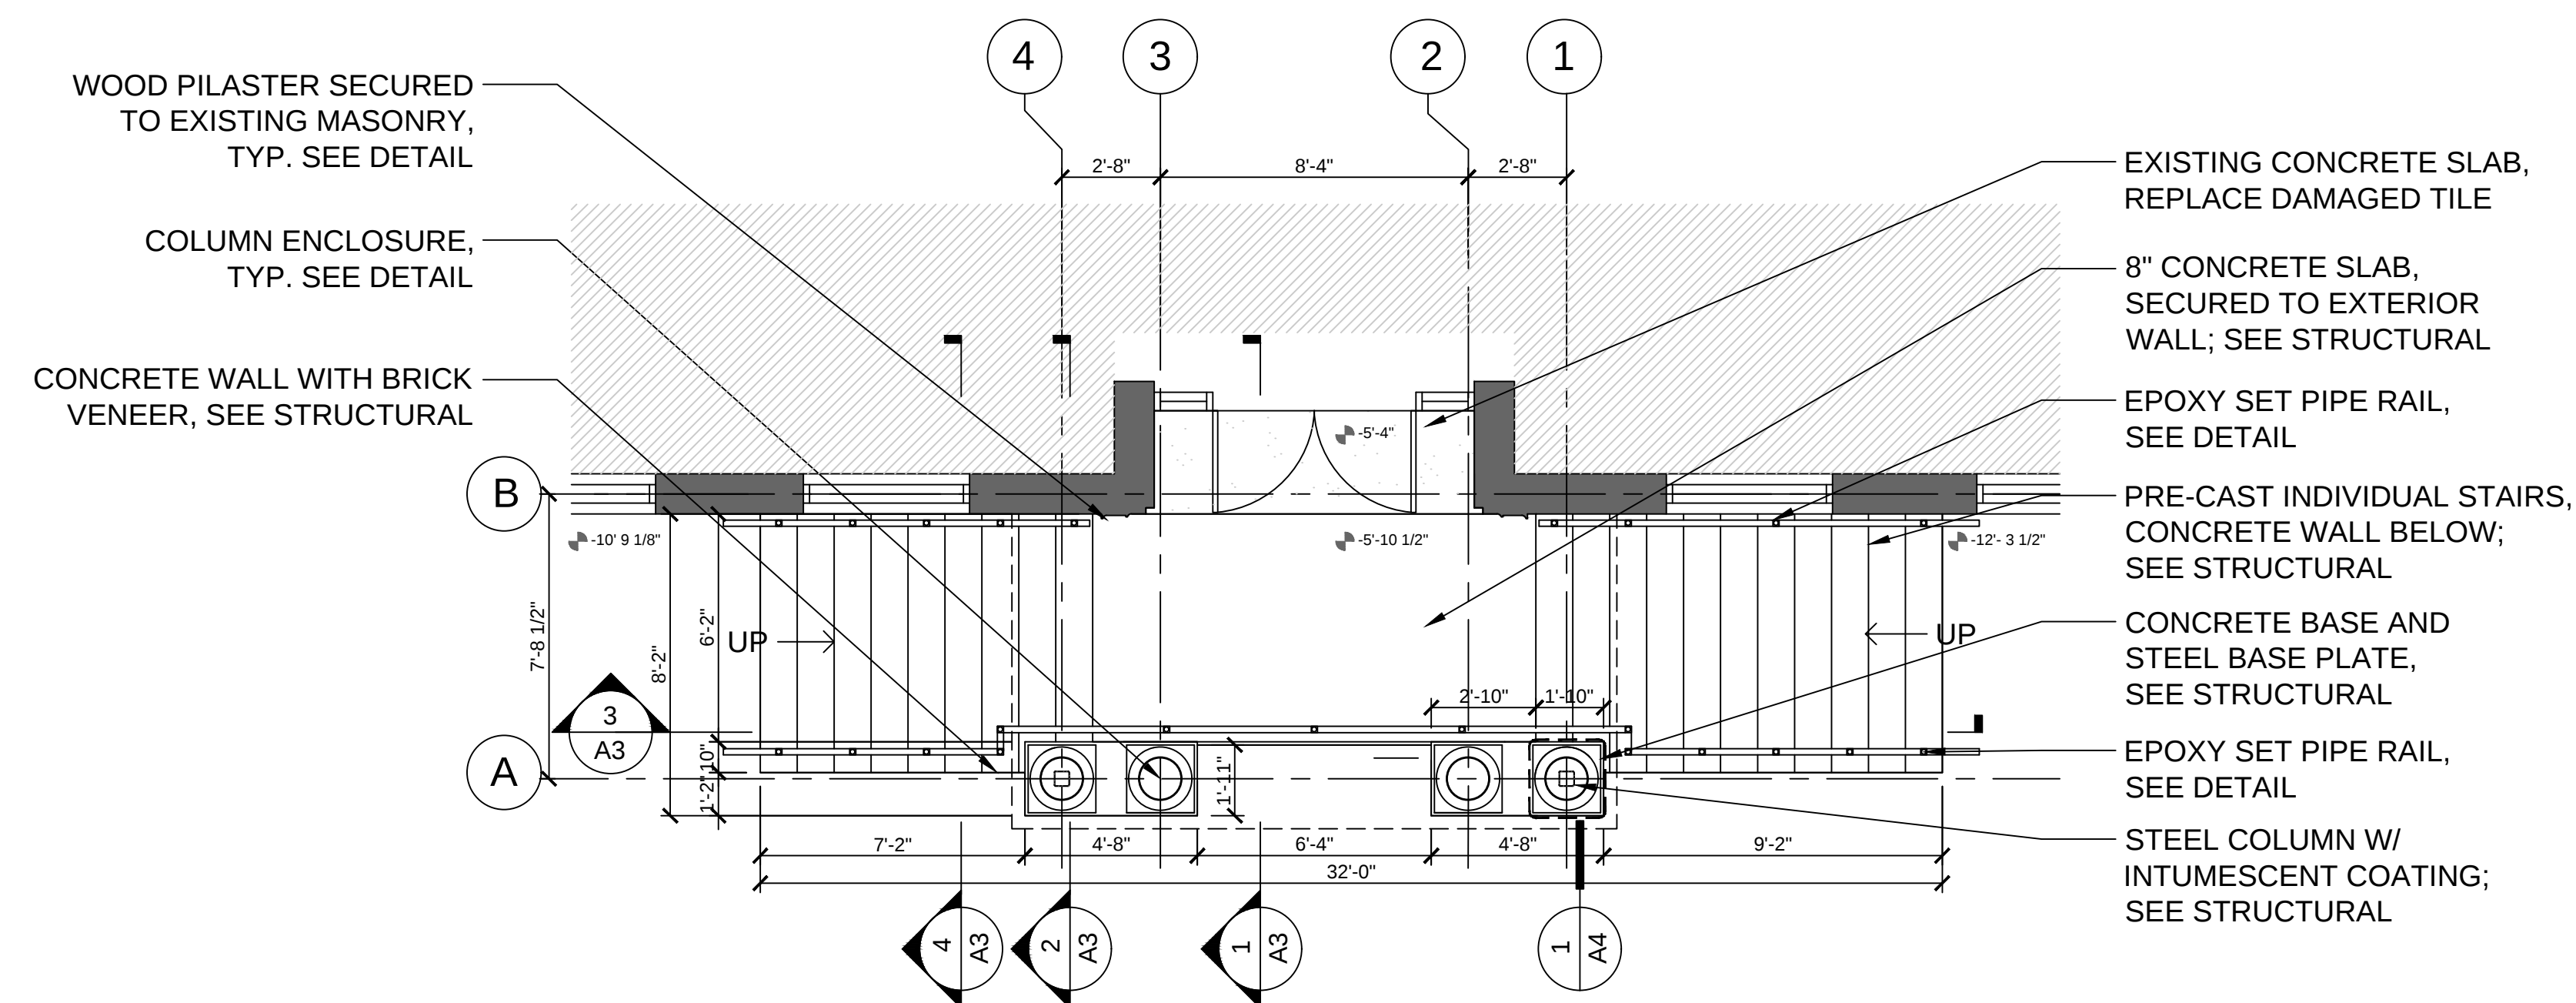

3 NEW PORTICO PLAN
Scale: 1/4" = 1'-0"

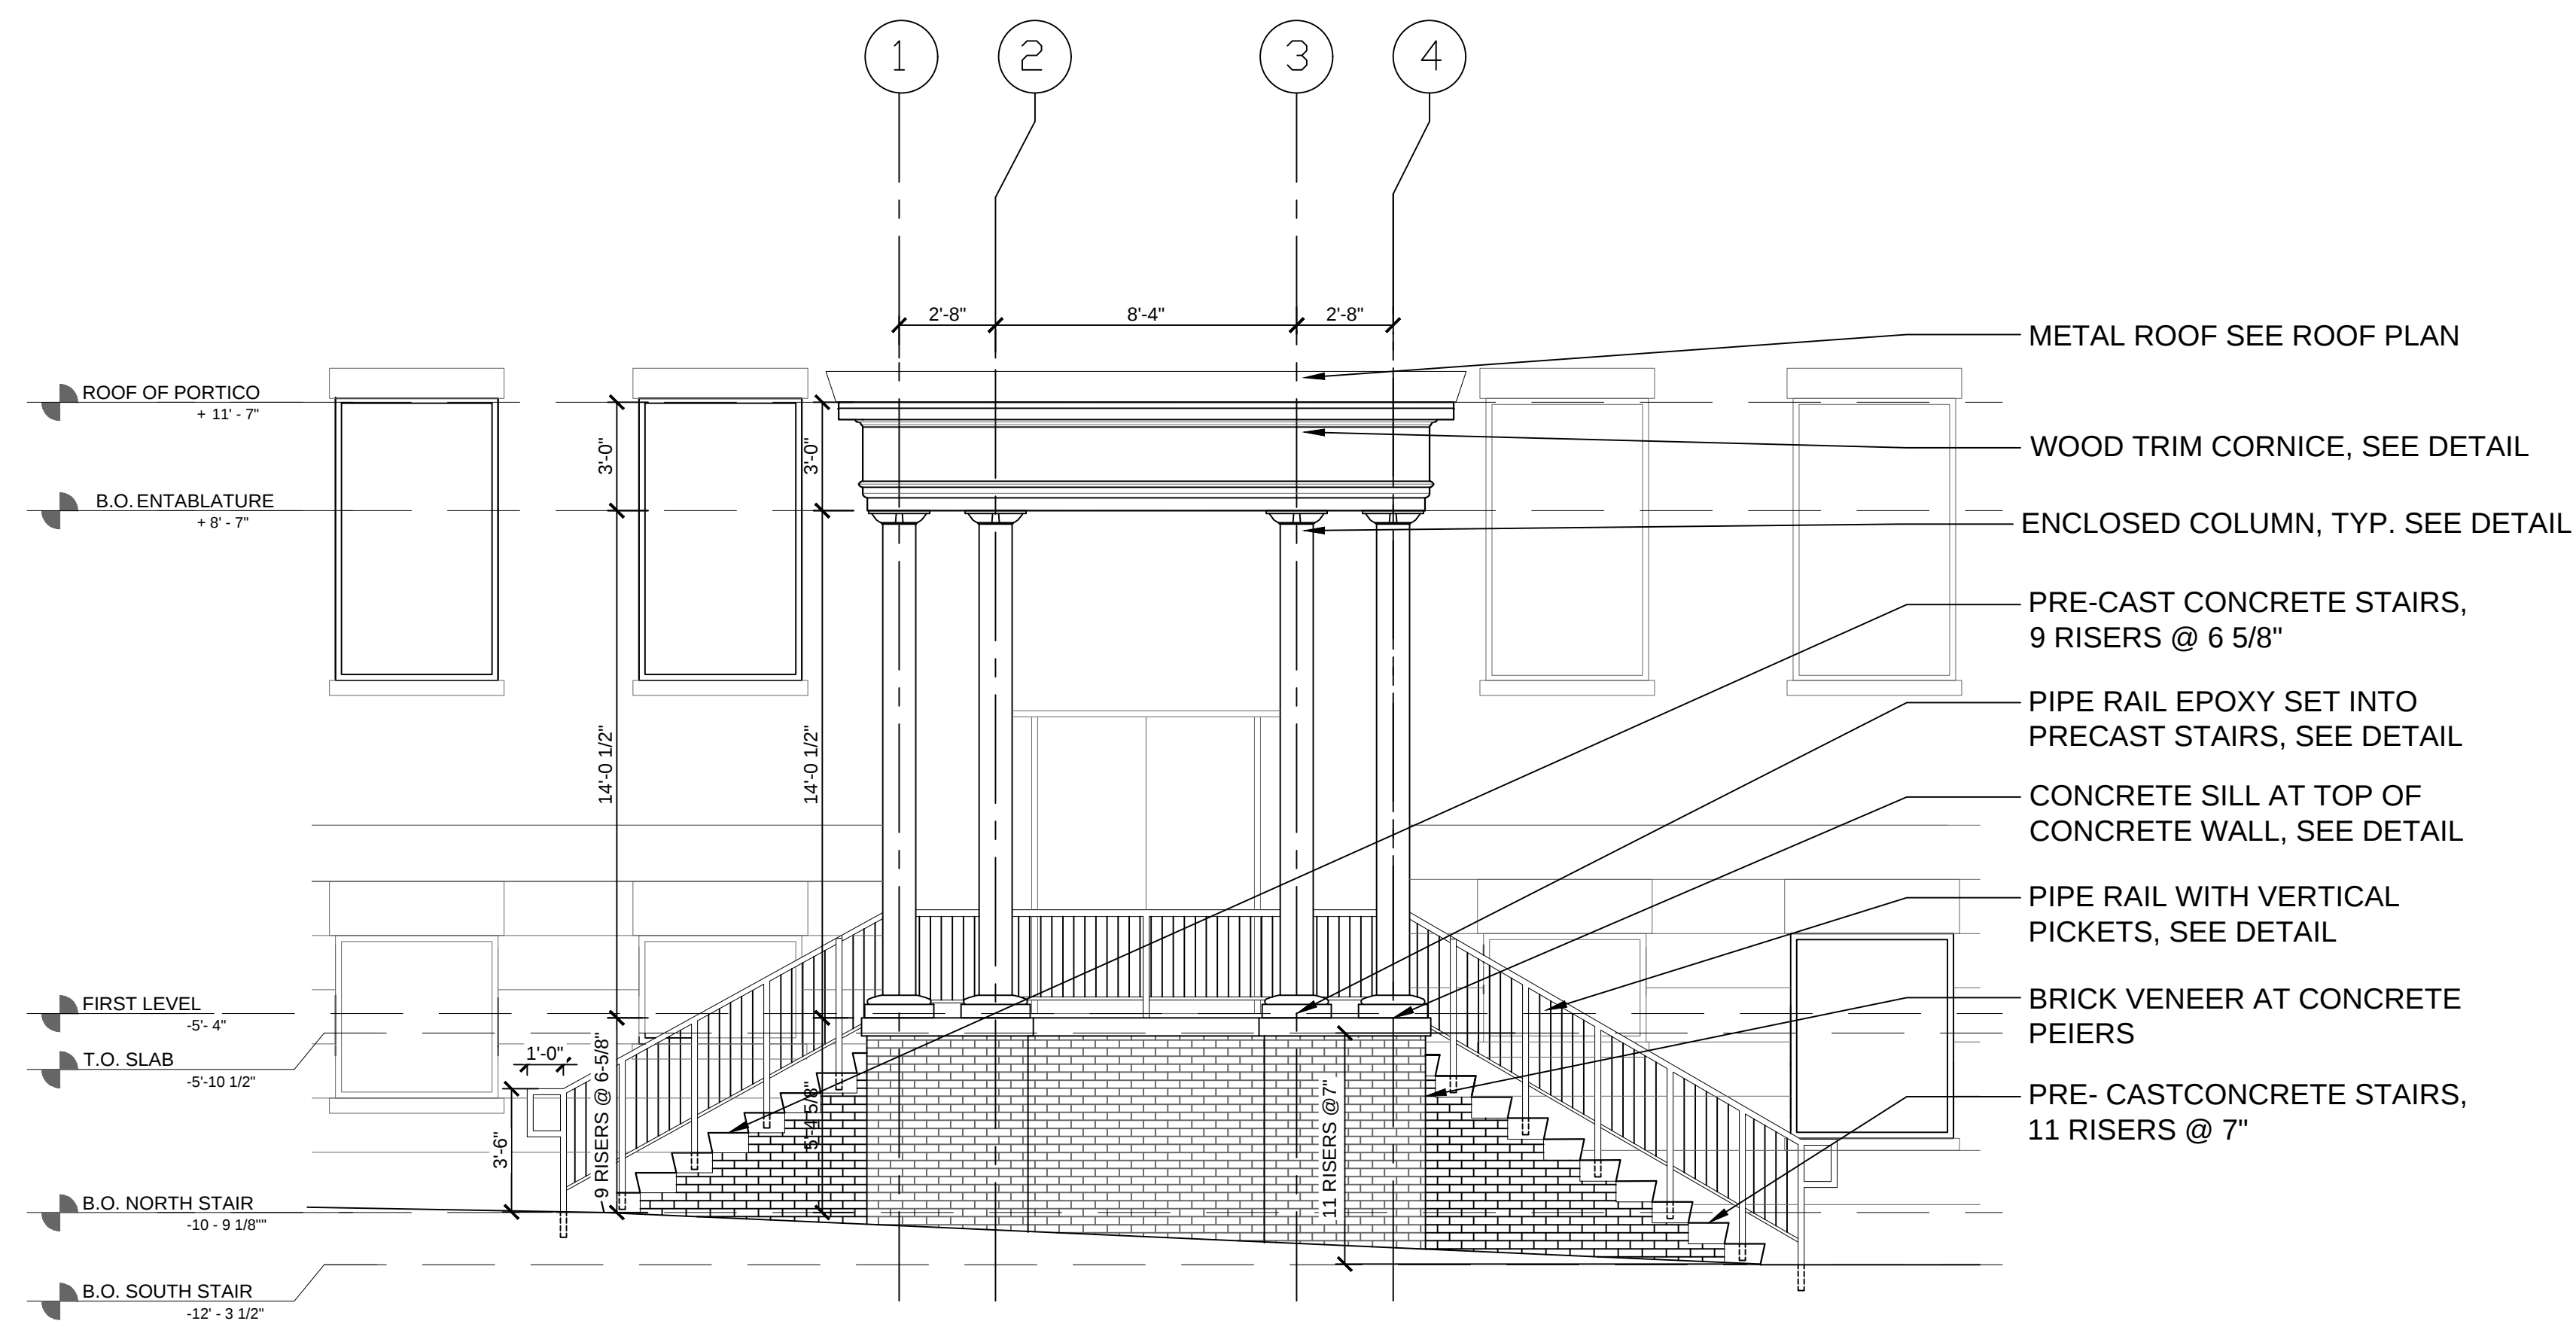

3 PORTICO NEW ELEVATION
Scale: 1/4" = 1'-0"






GALVANIZED STEEL HAND RAIL TO BE PAINTED, COORDINATE
PAINT COLOR AND PRODUCT WITH ARCHITECT



RECEPTION | OPTION B



RECEPTION | OPTION D

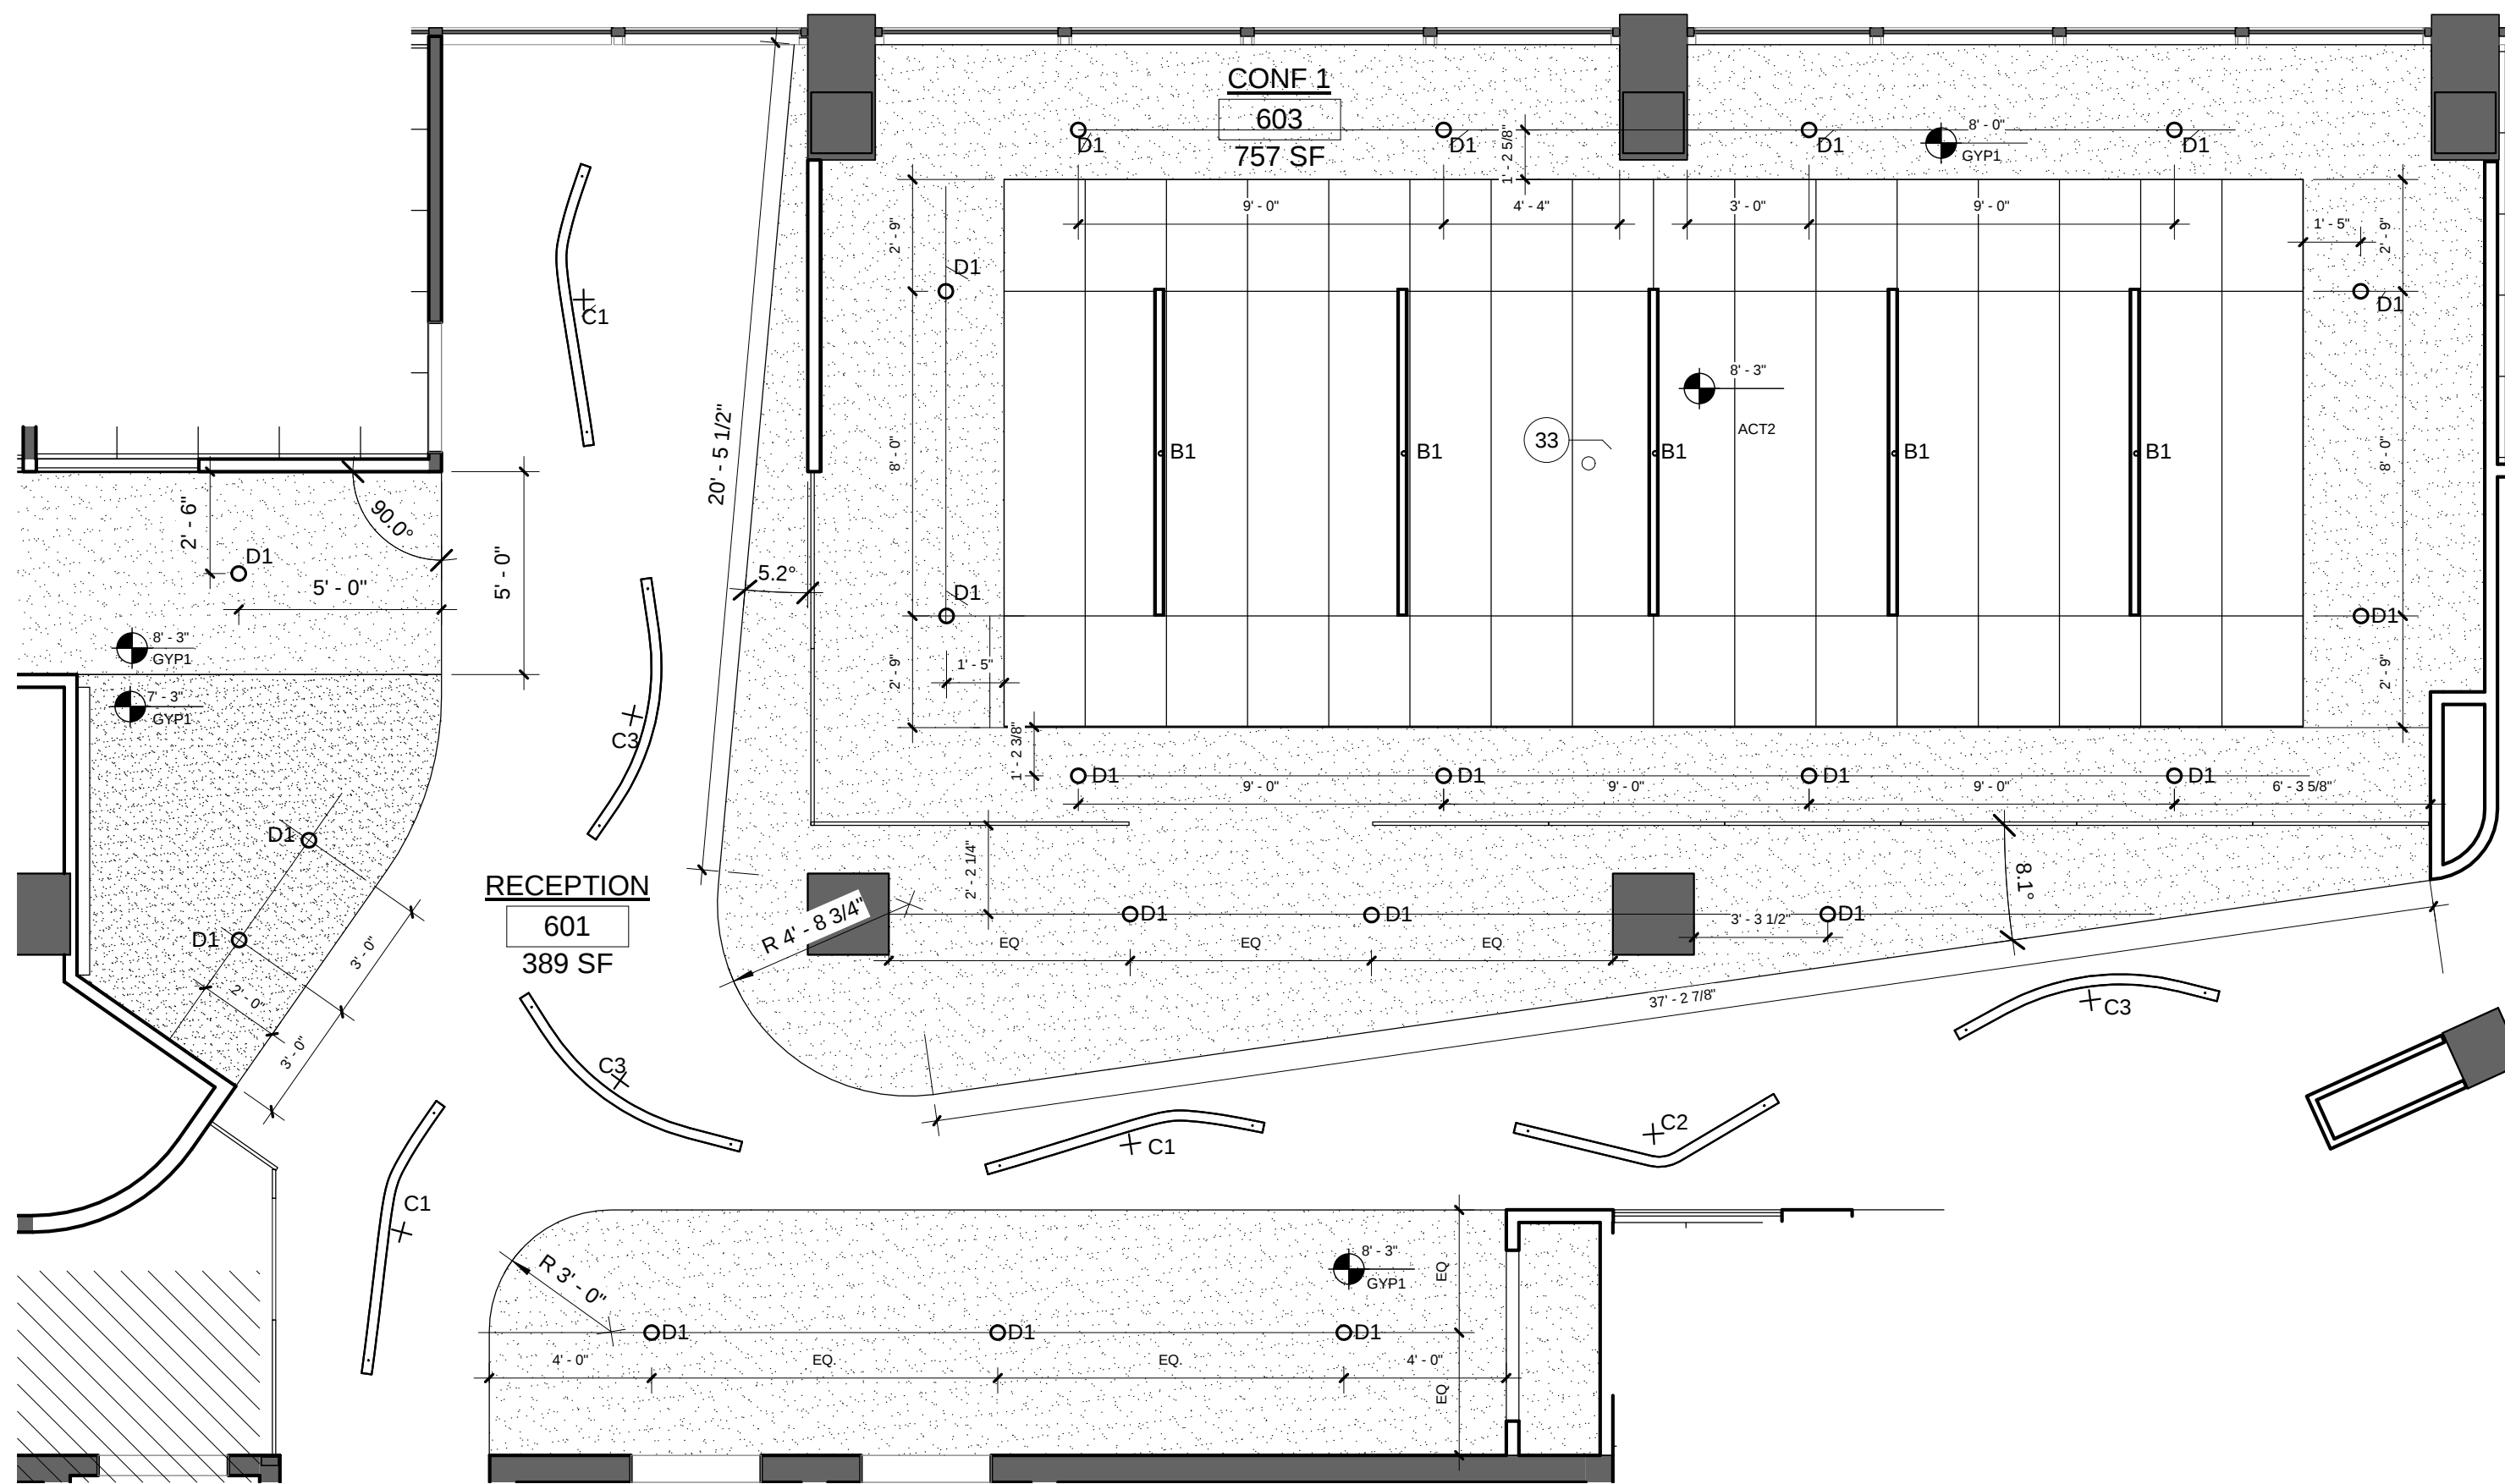

2 ENLARGED LOBBY CONFERENCE CEILING PLAN
1/4" = 1'-0"

CEILING LEGEND			
	EXP1. SEE MATERIAL SCHEDULE		ACT 1. SEE MATERIAL SCHEDULE
	GYP1. SEE MATERIAL SCHEDULE, SEE FINISH PLAN FOR PAINT COLOR		ACT 2. SEE MATERIAL SCHEDULE
A	24" x 24" LED TROFFER ACT CEILING RELOCATED EXISTING FIXTURE		
B1	3" X 8'-0" LINEAR SLOT LED MODEL: 3L-GRID-D-LENGTH-SOF-C1-30K-D065-D01-1C-UNV		
B2	3" X 6'-0" LINEAR SLOT LED MODEL: 3L-GRID-D-LENGTH-SOF-C1-30K-D065-D01-1C-UNV		
B3	3" X 4'-0" LINEAR SLOT LED MODEL: 3L-GRID-D-LENGTH-SOF-C1-30K-D065-D01-1C-UNV		
C1	2" CURVED DIRECT PENDANT MODEL: CPD2-L-8-30-H-S-CUSTOM CONFIG 1-S-W		
C2	2" CURVED DIRECT PENDANT MODEL: CPD2-L-8-30-H-S-CUSTOM CONFIG 1-S-W		
C3	2" CURVED DIRECT PENDANT MODEL: CPD2-L-8-30-H-S-CUSTOM CONFIG 1-S-W		
D1	6" LED DOWNLIGHT		
D2	6" LED DOWNLIGHT		
F	6" CYLINDER SURFACE		
G	6" LED WALL WASH		
H	TAPE LIGHT		
U	12" UTILITY RACK EXPOSED CEILING		
P1	CYLINDER PENDANT		
P2	CYLINDER PENDANT		
P4	CYLINDER PENDANT		